



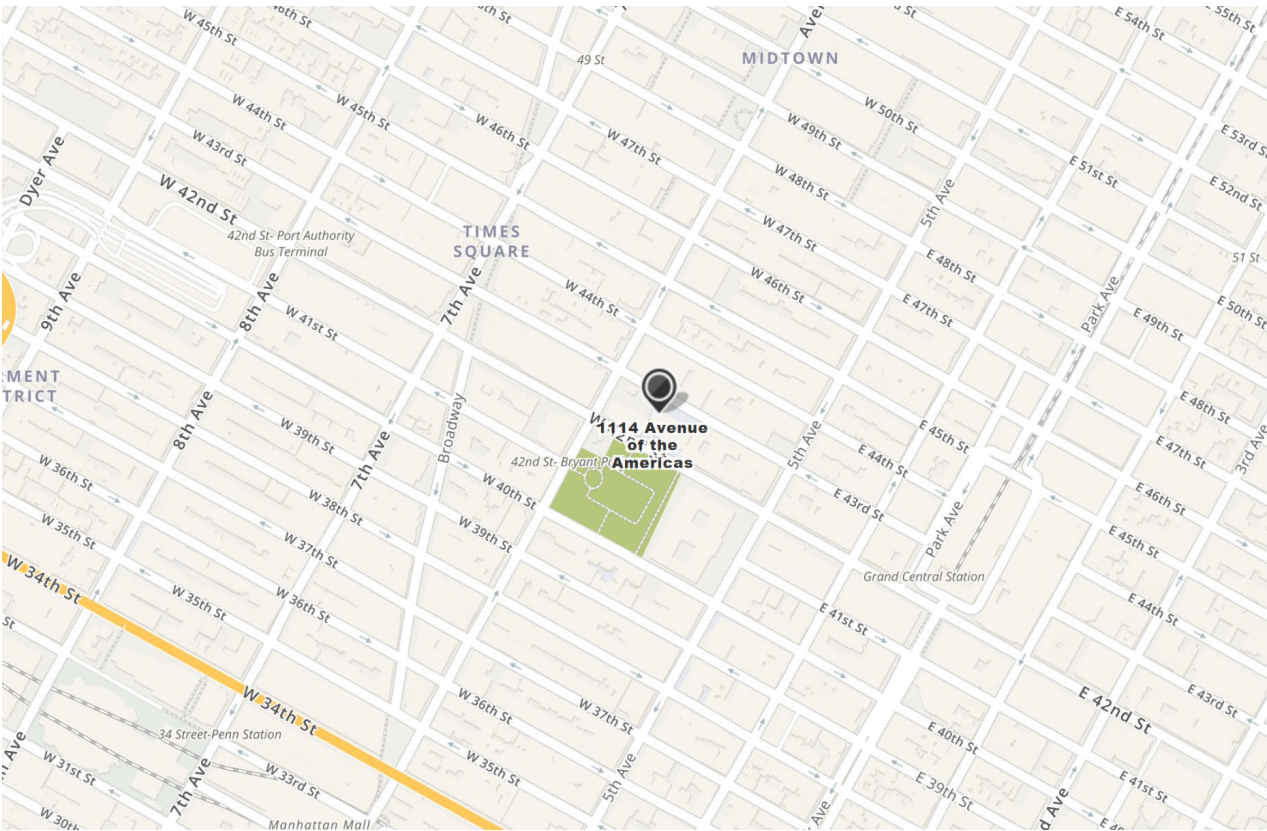

1114 6th Ave, New York, NY 10036

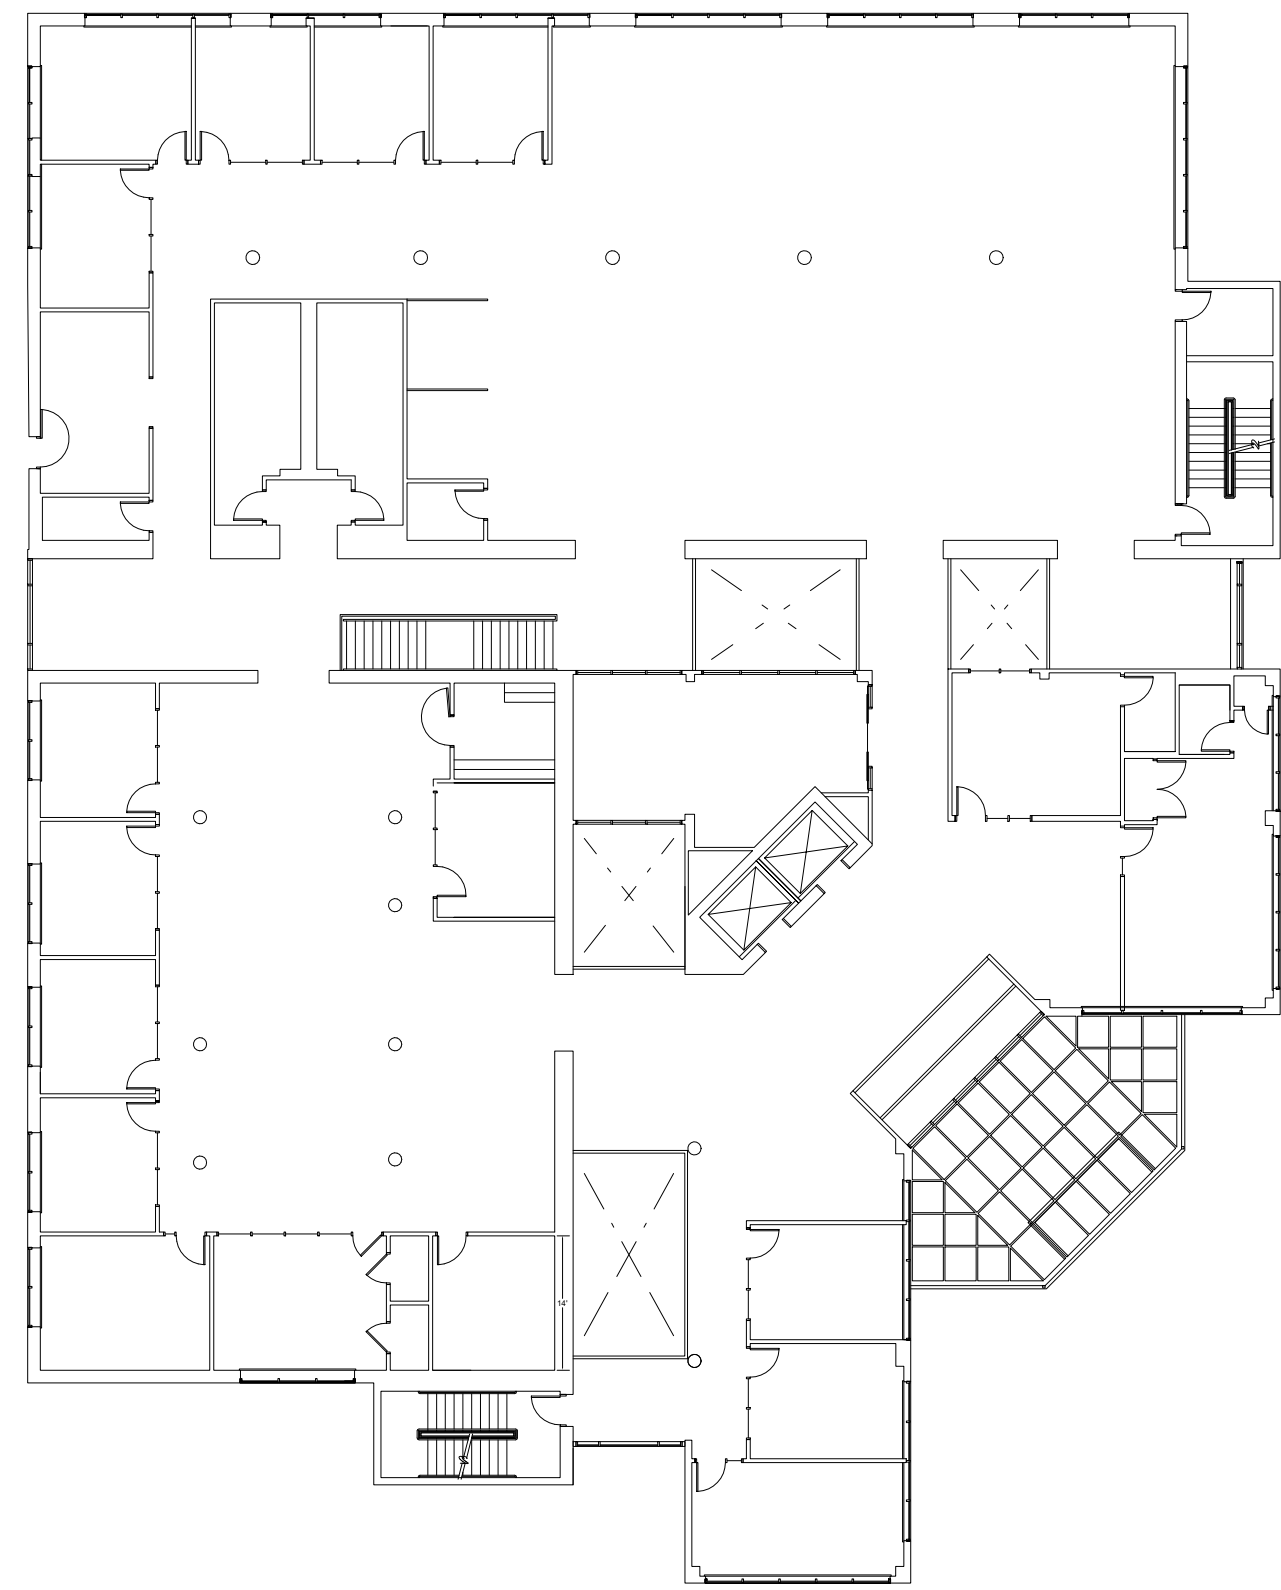

Existing Floor Plan
1" = 20'-0"



Departmental Diagram
3/32" = 1'-0"

Department Legend

- Customer Service
- Design Studio
- Ergonomics
- Global Accounts
- Marketing
- Order Entry

acous.
A.F.F
bldg.
cab.
clg.
col.
cont.
det.
dim.
dwg.
el.
elect.
equip.
exist.
ext.
fin.

acoustical
above finish floor
building
cabinet
ceiling
column
continuous
detail
dimensions
drawing
elevation
electrical
equipment
existing
exterior
finish

gen.
ht.
int.
lav.
mech.
min.
N.I.C
qb.
rm.
rr.
sect.
spec.
struct.
U.N.O
ur.
w.c.

general
height
interior
lavatory
mechanical
minimum
not in construction
quiet booth
room
restrooms
section
specification
structural
unless noted otherwise
urinal
water closet

Sheet List

Sheet Number	Sheet Name
A1. 00	Life Safety Plan
A1. 01	Demolition Plan
A1. 02	Floor Plan
A1. 03	Reflected Ceiling Plan
A1. 04	Furniture Plan
A1. 05	Finish Plan and Schedule
A1. 06	Power and Data Plan
A3. 01	Interior Detail
A3. 02	Interior Elevations and Enlarged Plans
A6. 01	Door Schedule
A9. 01	3D Views/ Perspectives
G0. 01	Title Page

Symbol Legend

	Door Tag		North Arrow
	Room Tag		View Name 1/8" = 1'-0"
	Section		Grid Head
	Elevation		Call Out Head

Abbreviations

HUMANSCALE

Headquarters: Office Space
New York, New York

Client Name:

Project Name:

Project Number:
0123456789

Date Issued:
August 28, 2017

Sheet Content:


Project Information
Site
Abbreviations
Symbol Legends
Sheet List
Block Diagram

Drawn by: J.I.
Checked by: N.K.

Sheet Name:

Title Page

G0.01

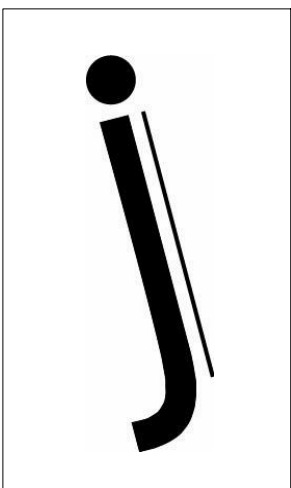

HUMANSCALE

Headquarters: Office Space
New York, New York

Client
Name:

Project
Name:

Project Number:
0123456789

Date Issued:
August 28, 2017

Sheet Content:


Life Safety Plan
Codes

Drawn by: J.I.
Checked by: N.K.

Sheet Name:

Life Safety Plan

A1.00

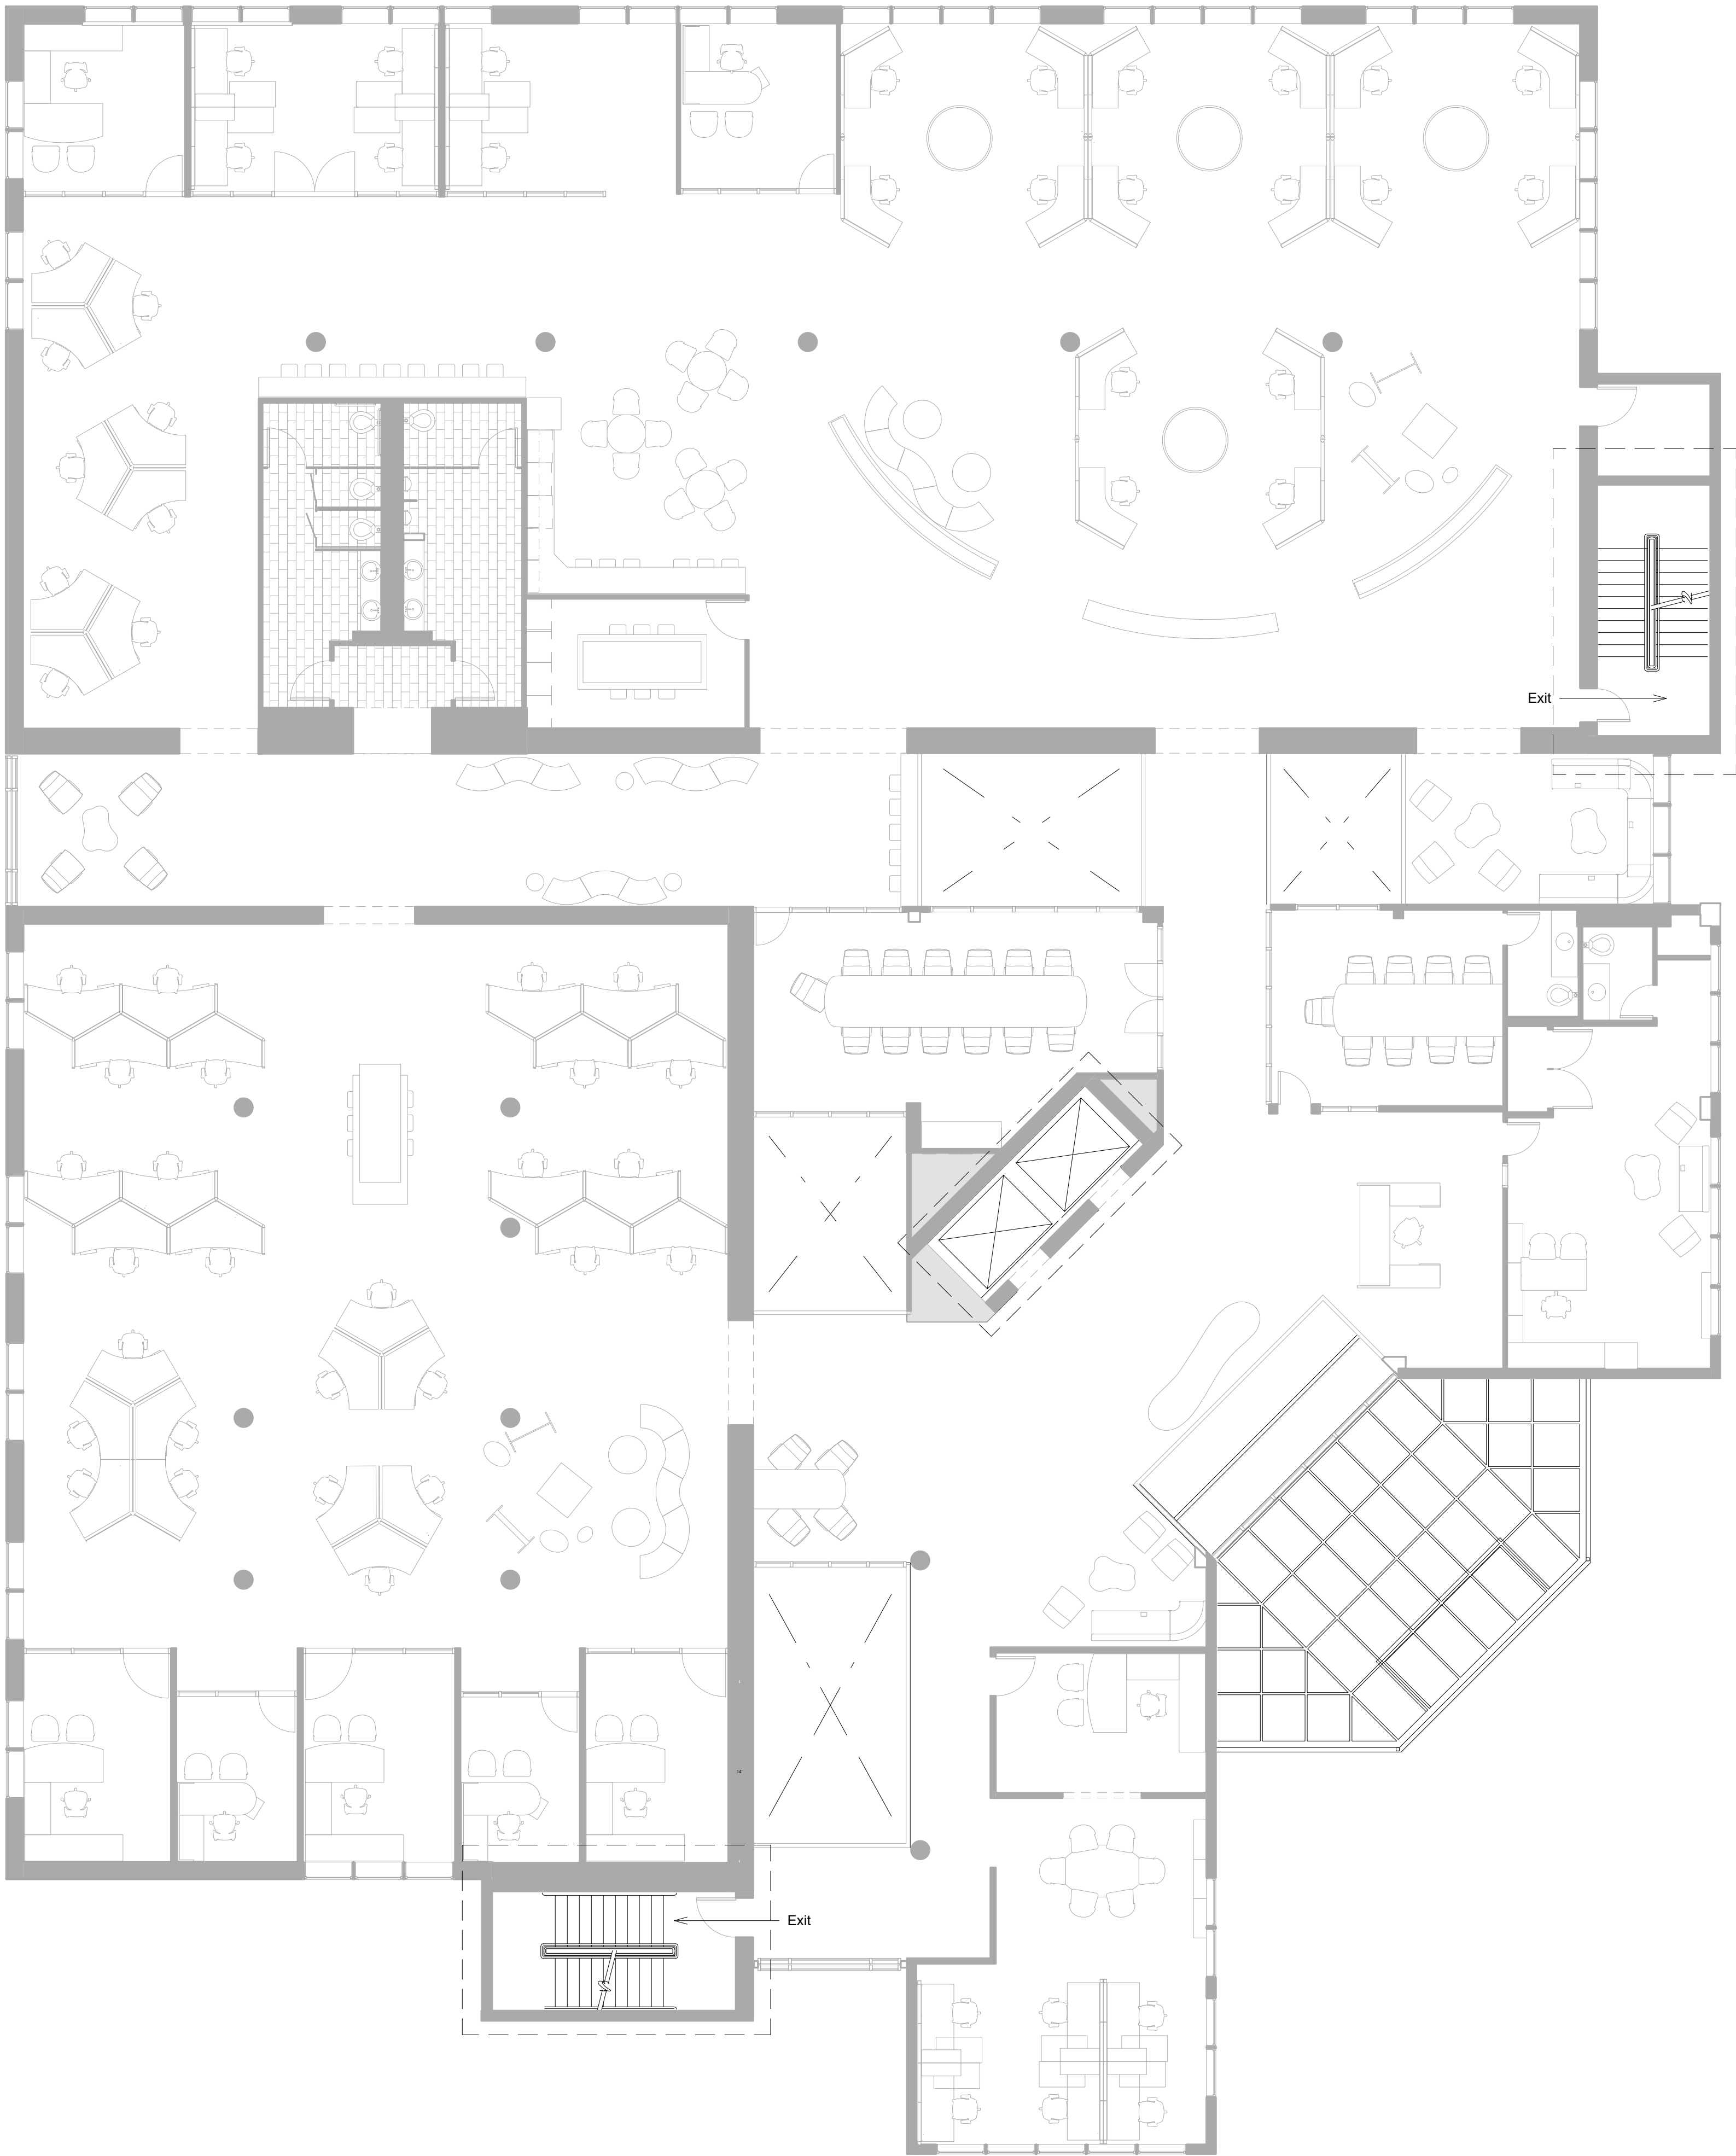

Codes:

Occupancy Classification: B, Business
Occupant Load: 175
Construction Type: IIB

Number of Exits: 2
Dead End Corridor Limit: Maximum Condition: 20 ft
Travel Distance to Exit: Maximum Condition: 300 ft


Men's Toilets:
Water Closets: 1
Urinals: 2
Lavatories: 2

Women's Toilets:
Water Closets: 3
Lavatories: 2

Unisex:
Janitor Closets: 1
Drinking Fountains: 1

← Exit

--- Fire-Rated Walls

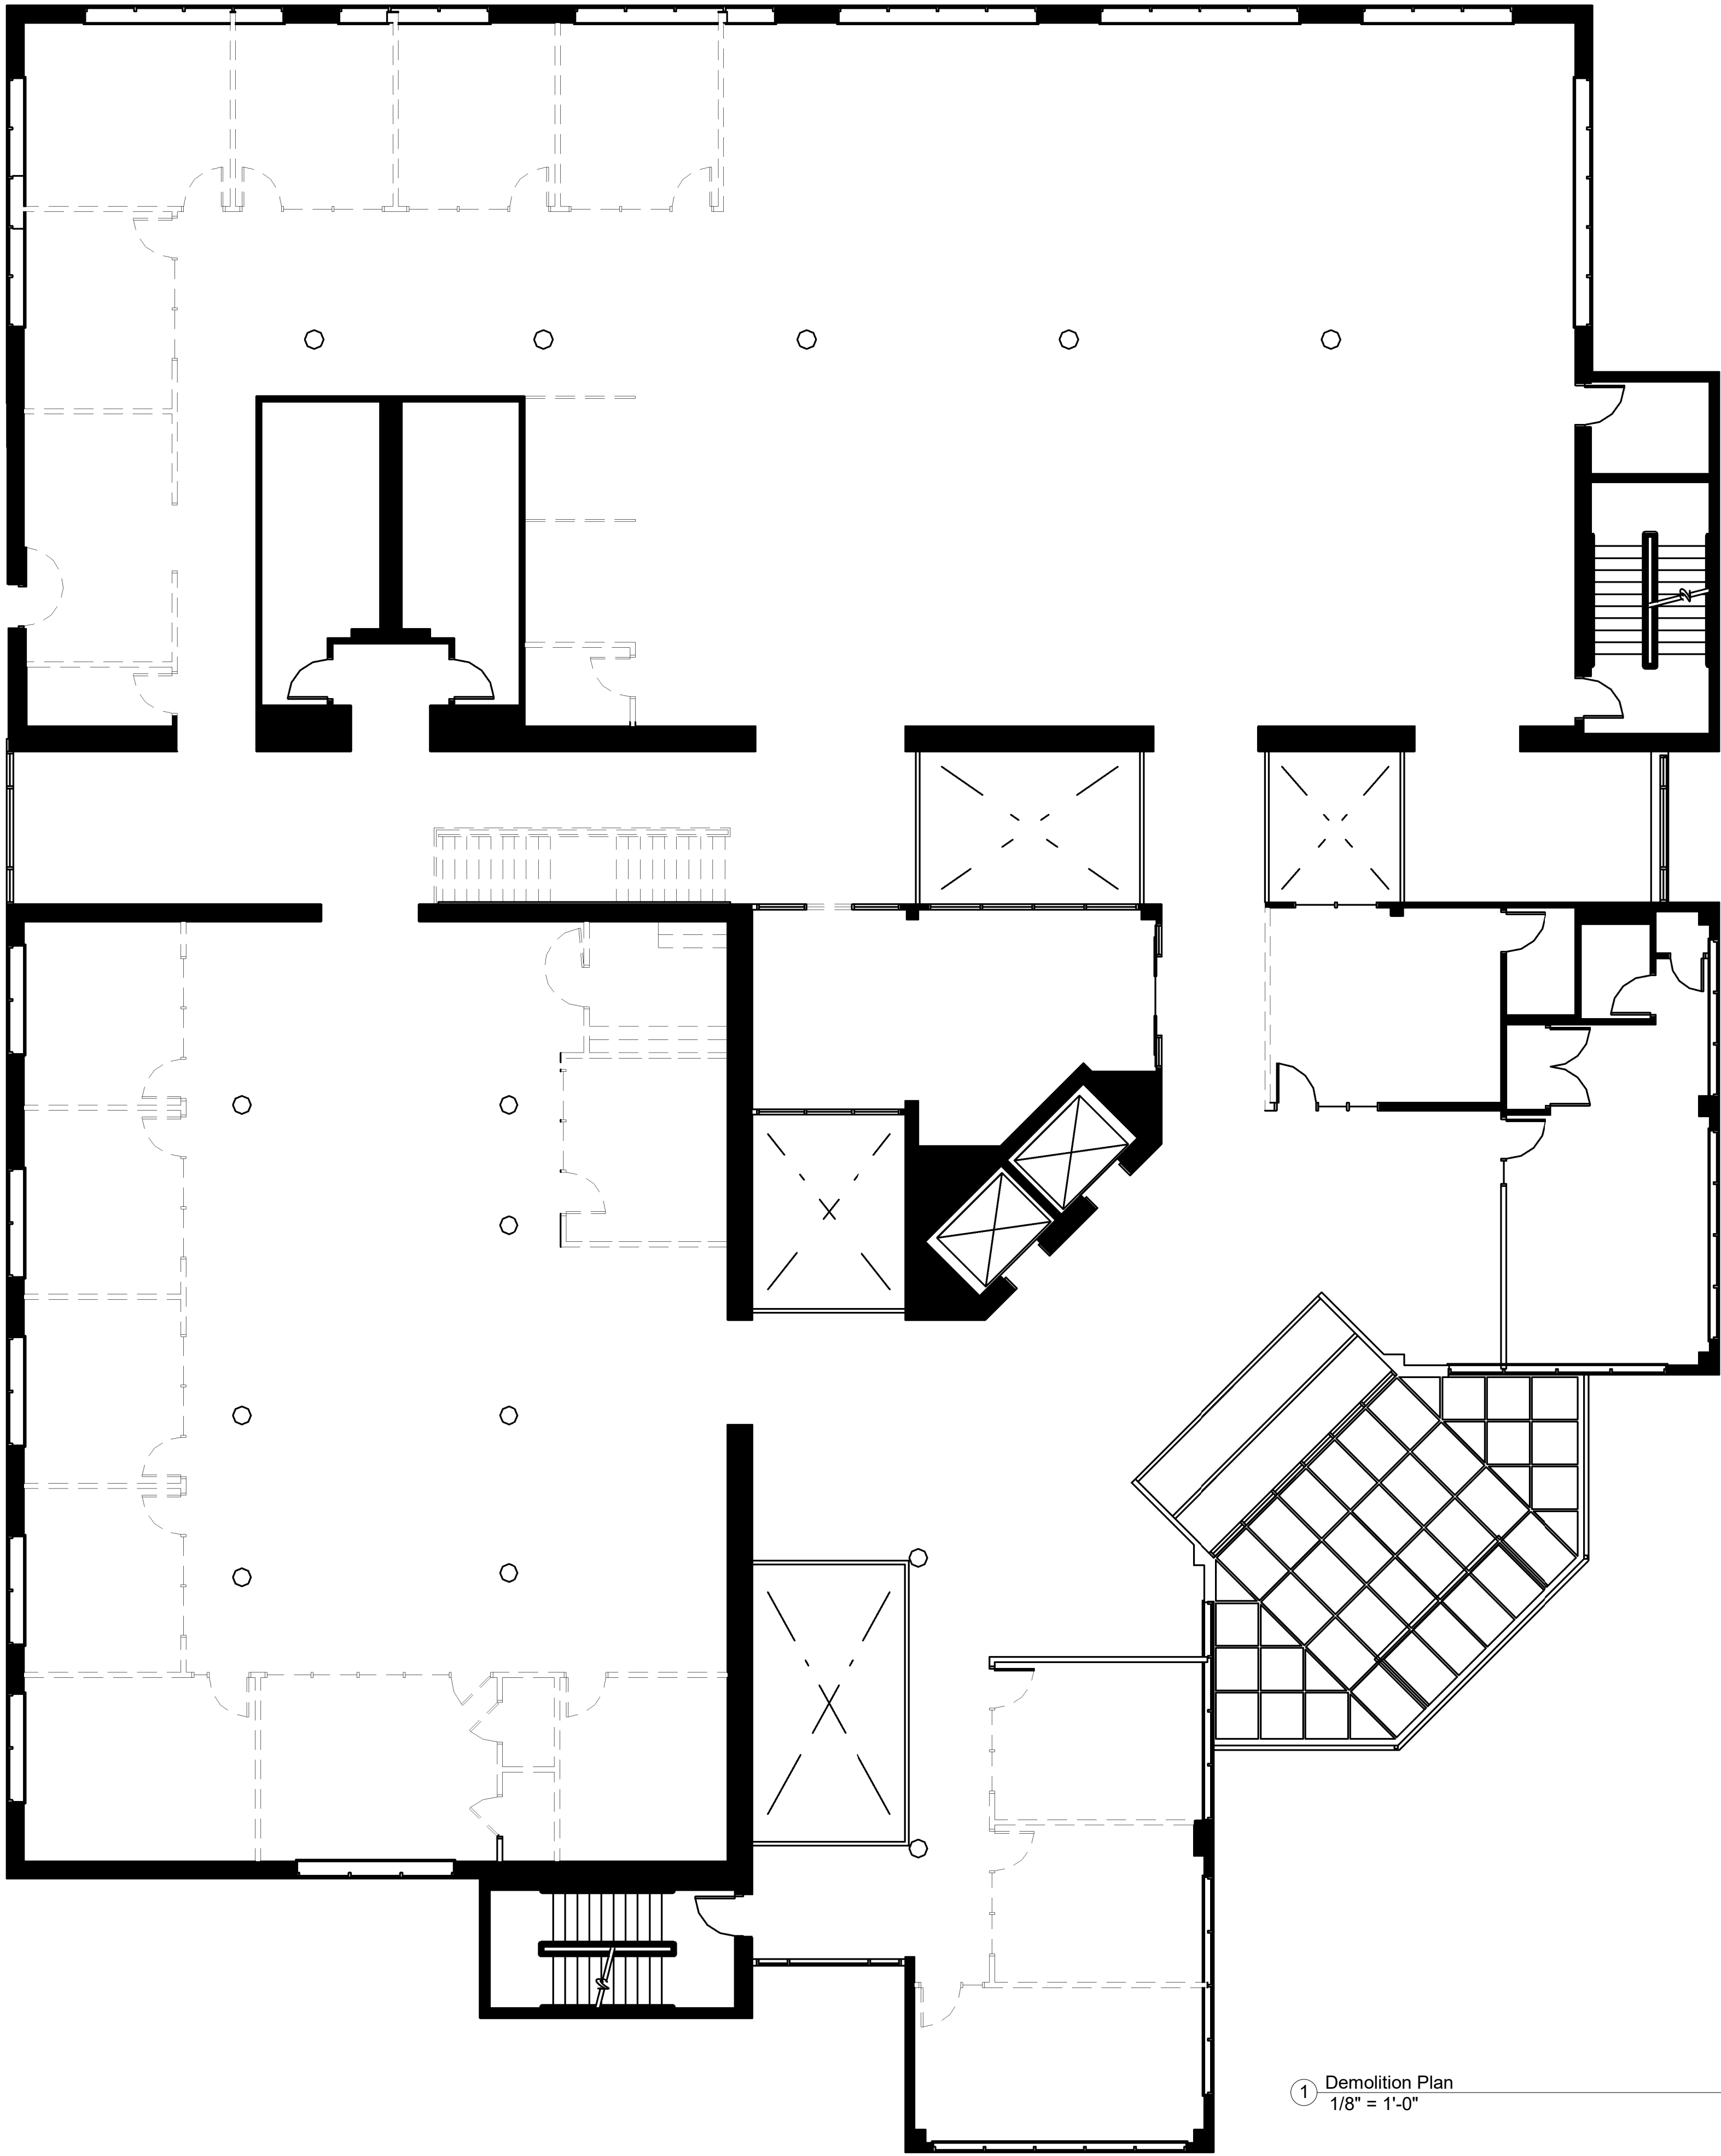


① Demolition Plan
1/8" = 1'-0"



General Notes:

1. All existing exterior windows and doors to remain U.N.O.
2. G.C. to remove all existing finishes and prepare surfaces to receive new finishes.

----- = Walls to be demolished
————— = Existing Walls to remain

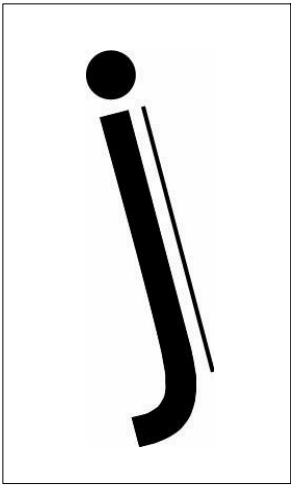

HUMANSCALE

Headquarters: Office Space
New York, New York

Client Name:

Project Name:

Project Number:
0123456789

Date Issued:
August 28, 2017


Sheet Content:

Demolition Plan
General Notes

Drawn by: J.I.
Checked by: N.K.

Sheet Name:

Demolition Plan

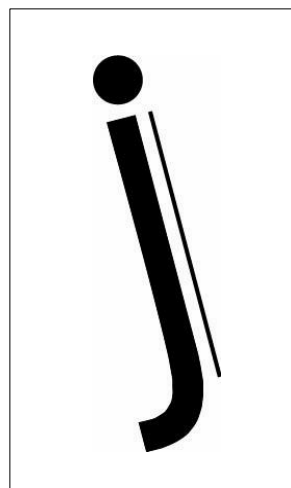

HUMANSCALE

Headquarters: Office Space
New York, New York

Client
Name:

Project
Name:

Project Number:
0123456789

Date Issued:
August 28, 2017

Sheet Content:


Floor Plan
General Notes
Keynotes

Drawn by: J.I.
Checked by: N.K.

Sheet Name:

Floor Plan

A1. 02

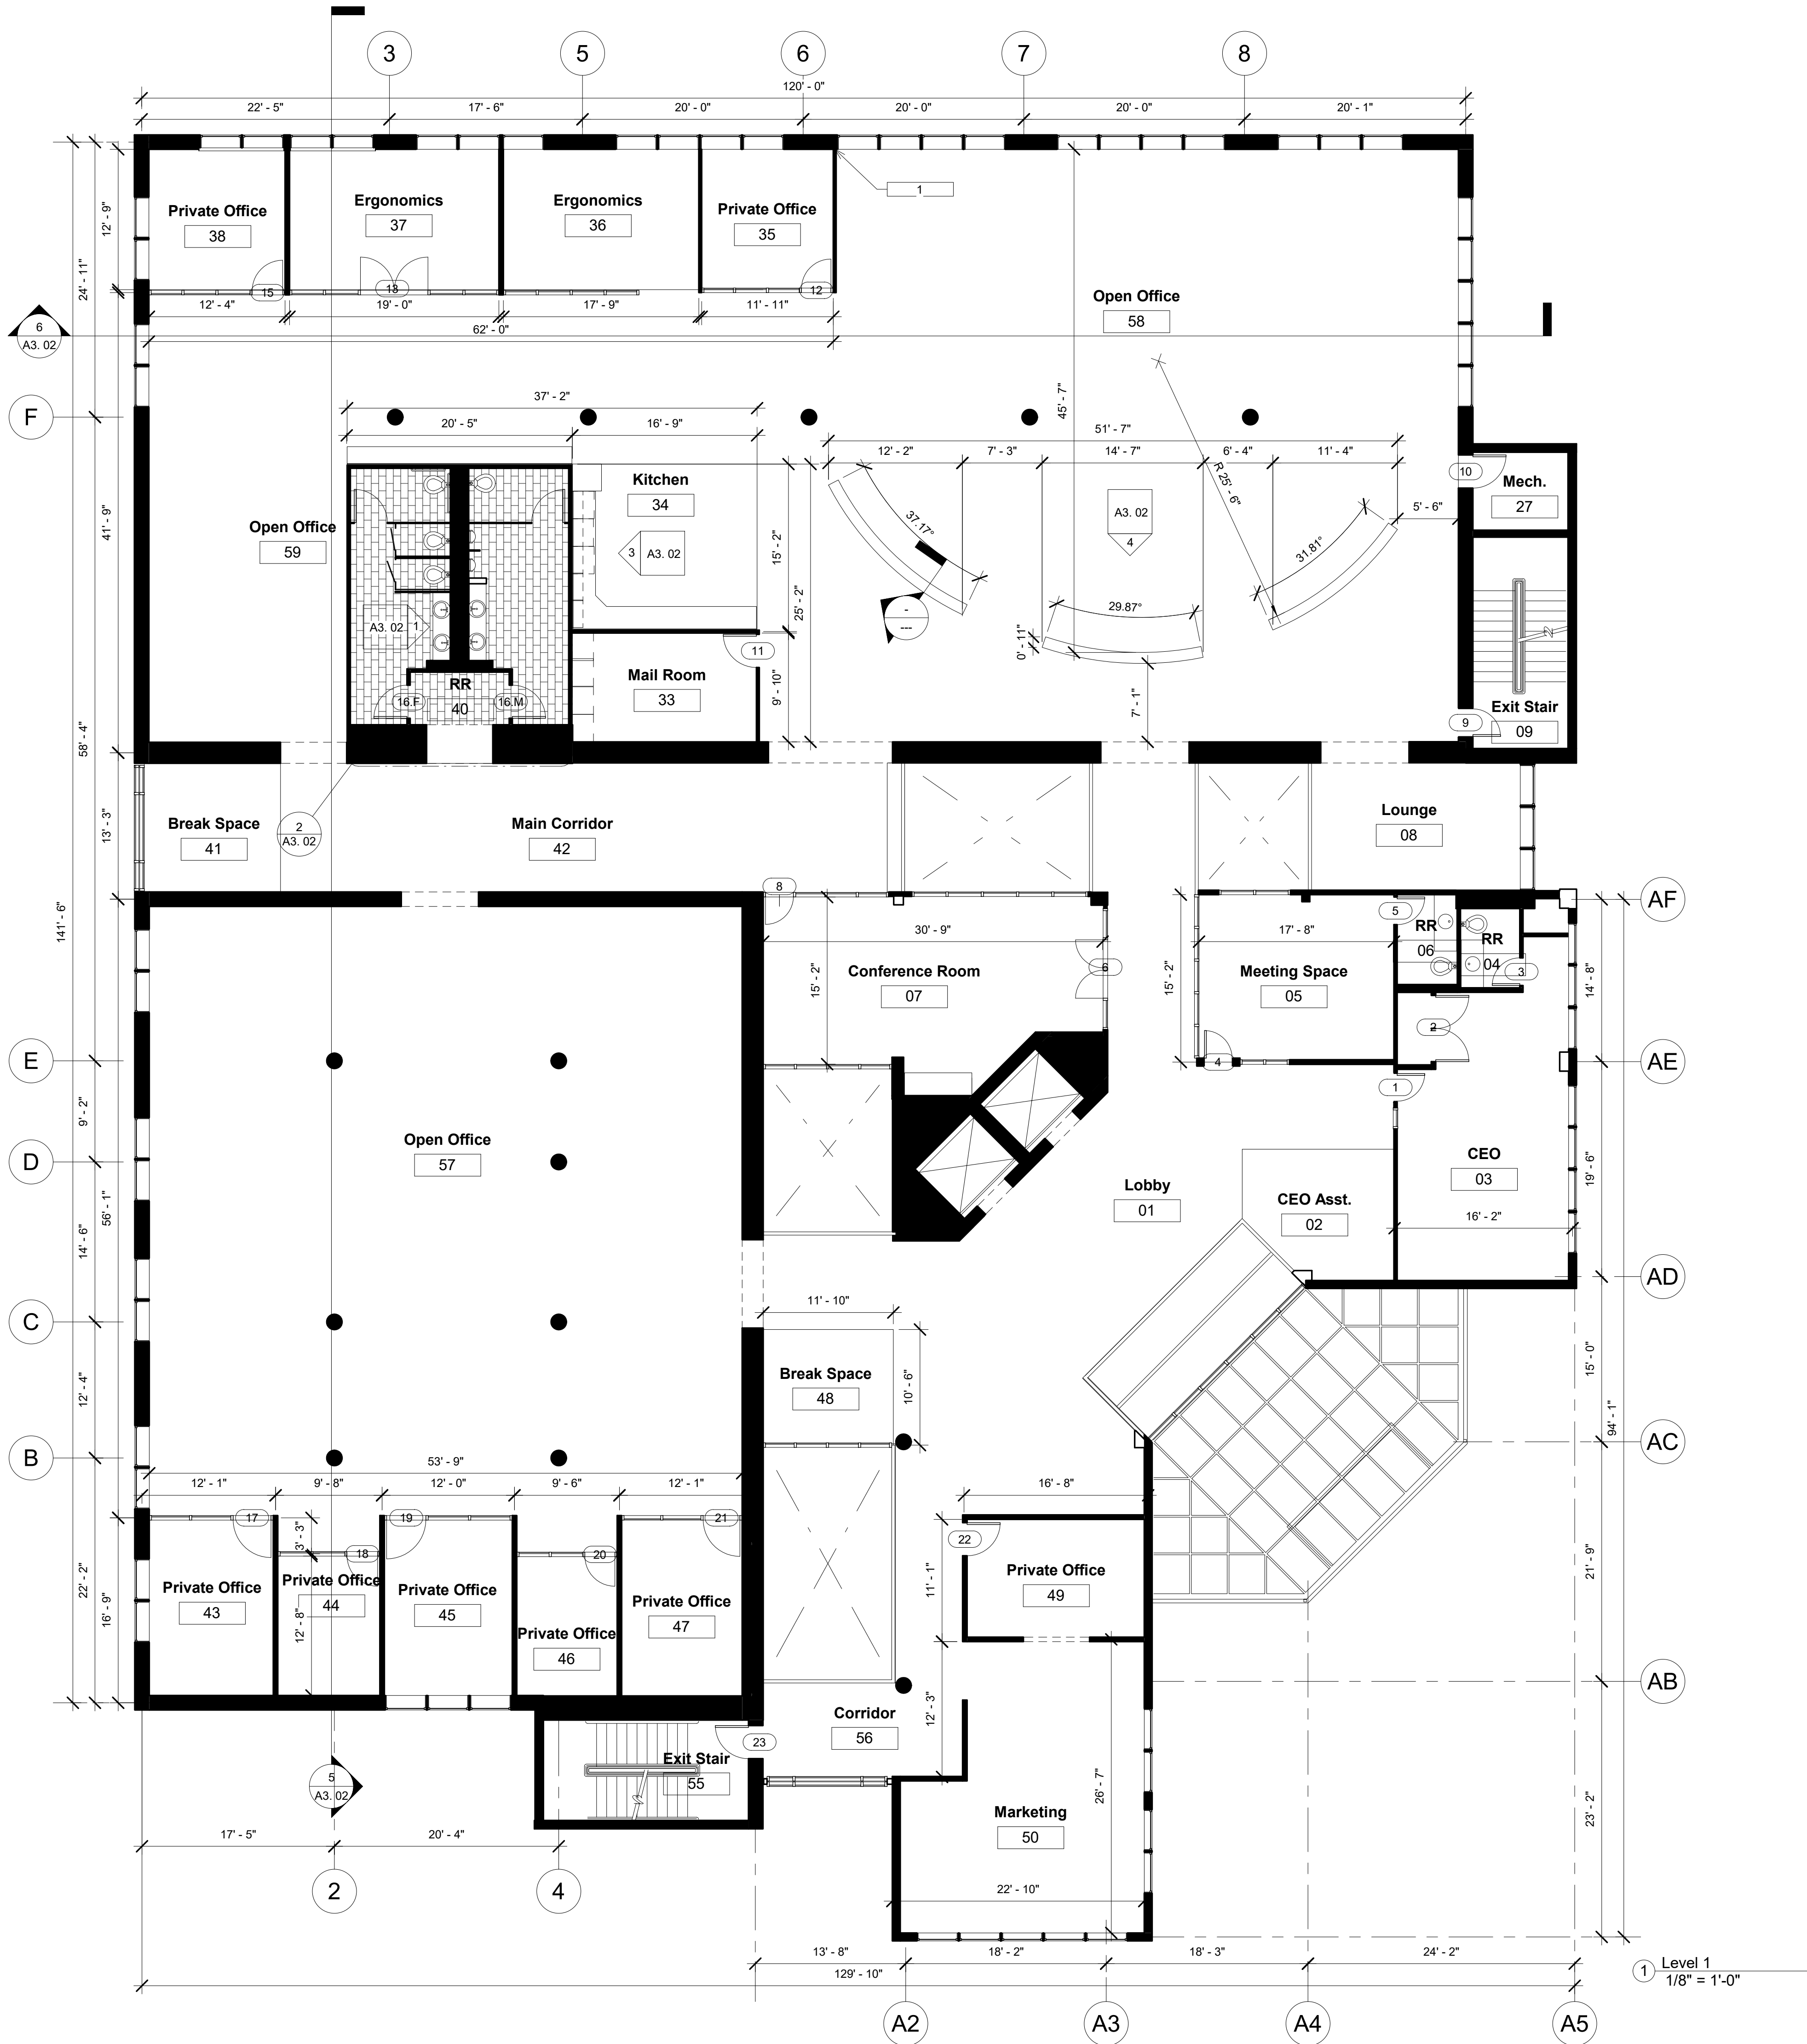


General Notes:

1. All existing exterior walls and windows to remain
2. G.C. to remove all existing finishes and prepare surfaces to receive new finishes
3. All interior wall to be Gyp. Bd 5 3/4"
4. All dims are to the face of the wall U.N.O. or to centerline.

Keynotes:

1. Align wall to window

1 Level 1
1/8" = 1'-0"

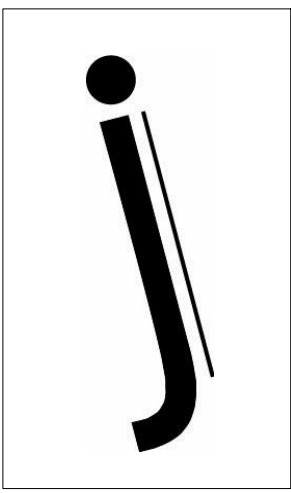

HUMANSCALE

Headquarters: Office Space
New York, New York

Client
Name:

Project
Name:

Project Number:
0123456789

Date Issued:
August 28, 2017

Sheet Content:

Reflected Ceiling Plan
General Notes
Keynotes
Fixture Legend

Drawn by: J.I.

Checked by: N.K.

Sheet Name:

Reflected Ceiling Plan

A1. 03



General Notes:

- Overall existing ceiling height at 10'- 4" A.F.F.
- All ACT ceiling at 9'-4" A.F.F.
- All Gypsum ceiling in Open Offices to be 10'-0" A.F.F.
- All soffit 1' tall at 9'-0" A.F.F
- Always center lights on ACT


Keynotes:


- Aktura Atmospera Ceiling System

Fixture Legend

- 6" Recessed Incandescent Wall Washer
- 6" Recessed Incandescent Downlight
- Zero LED Pendant
- Coronet Linear LED
- 2' x 4' LED Troffer
- Vibia LED Pendant
- 2' x 4' ACT

 Level 1
1/8" = 1'-0"



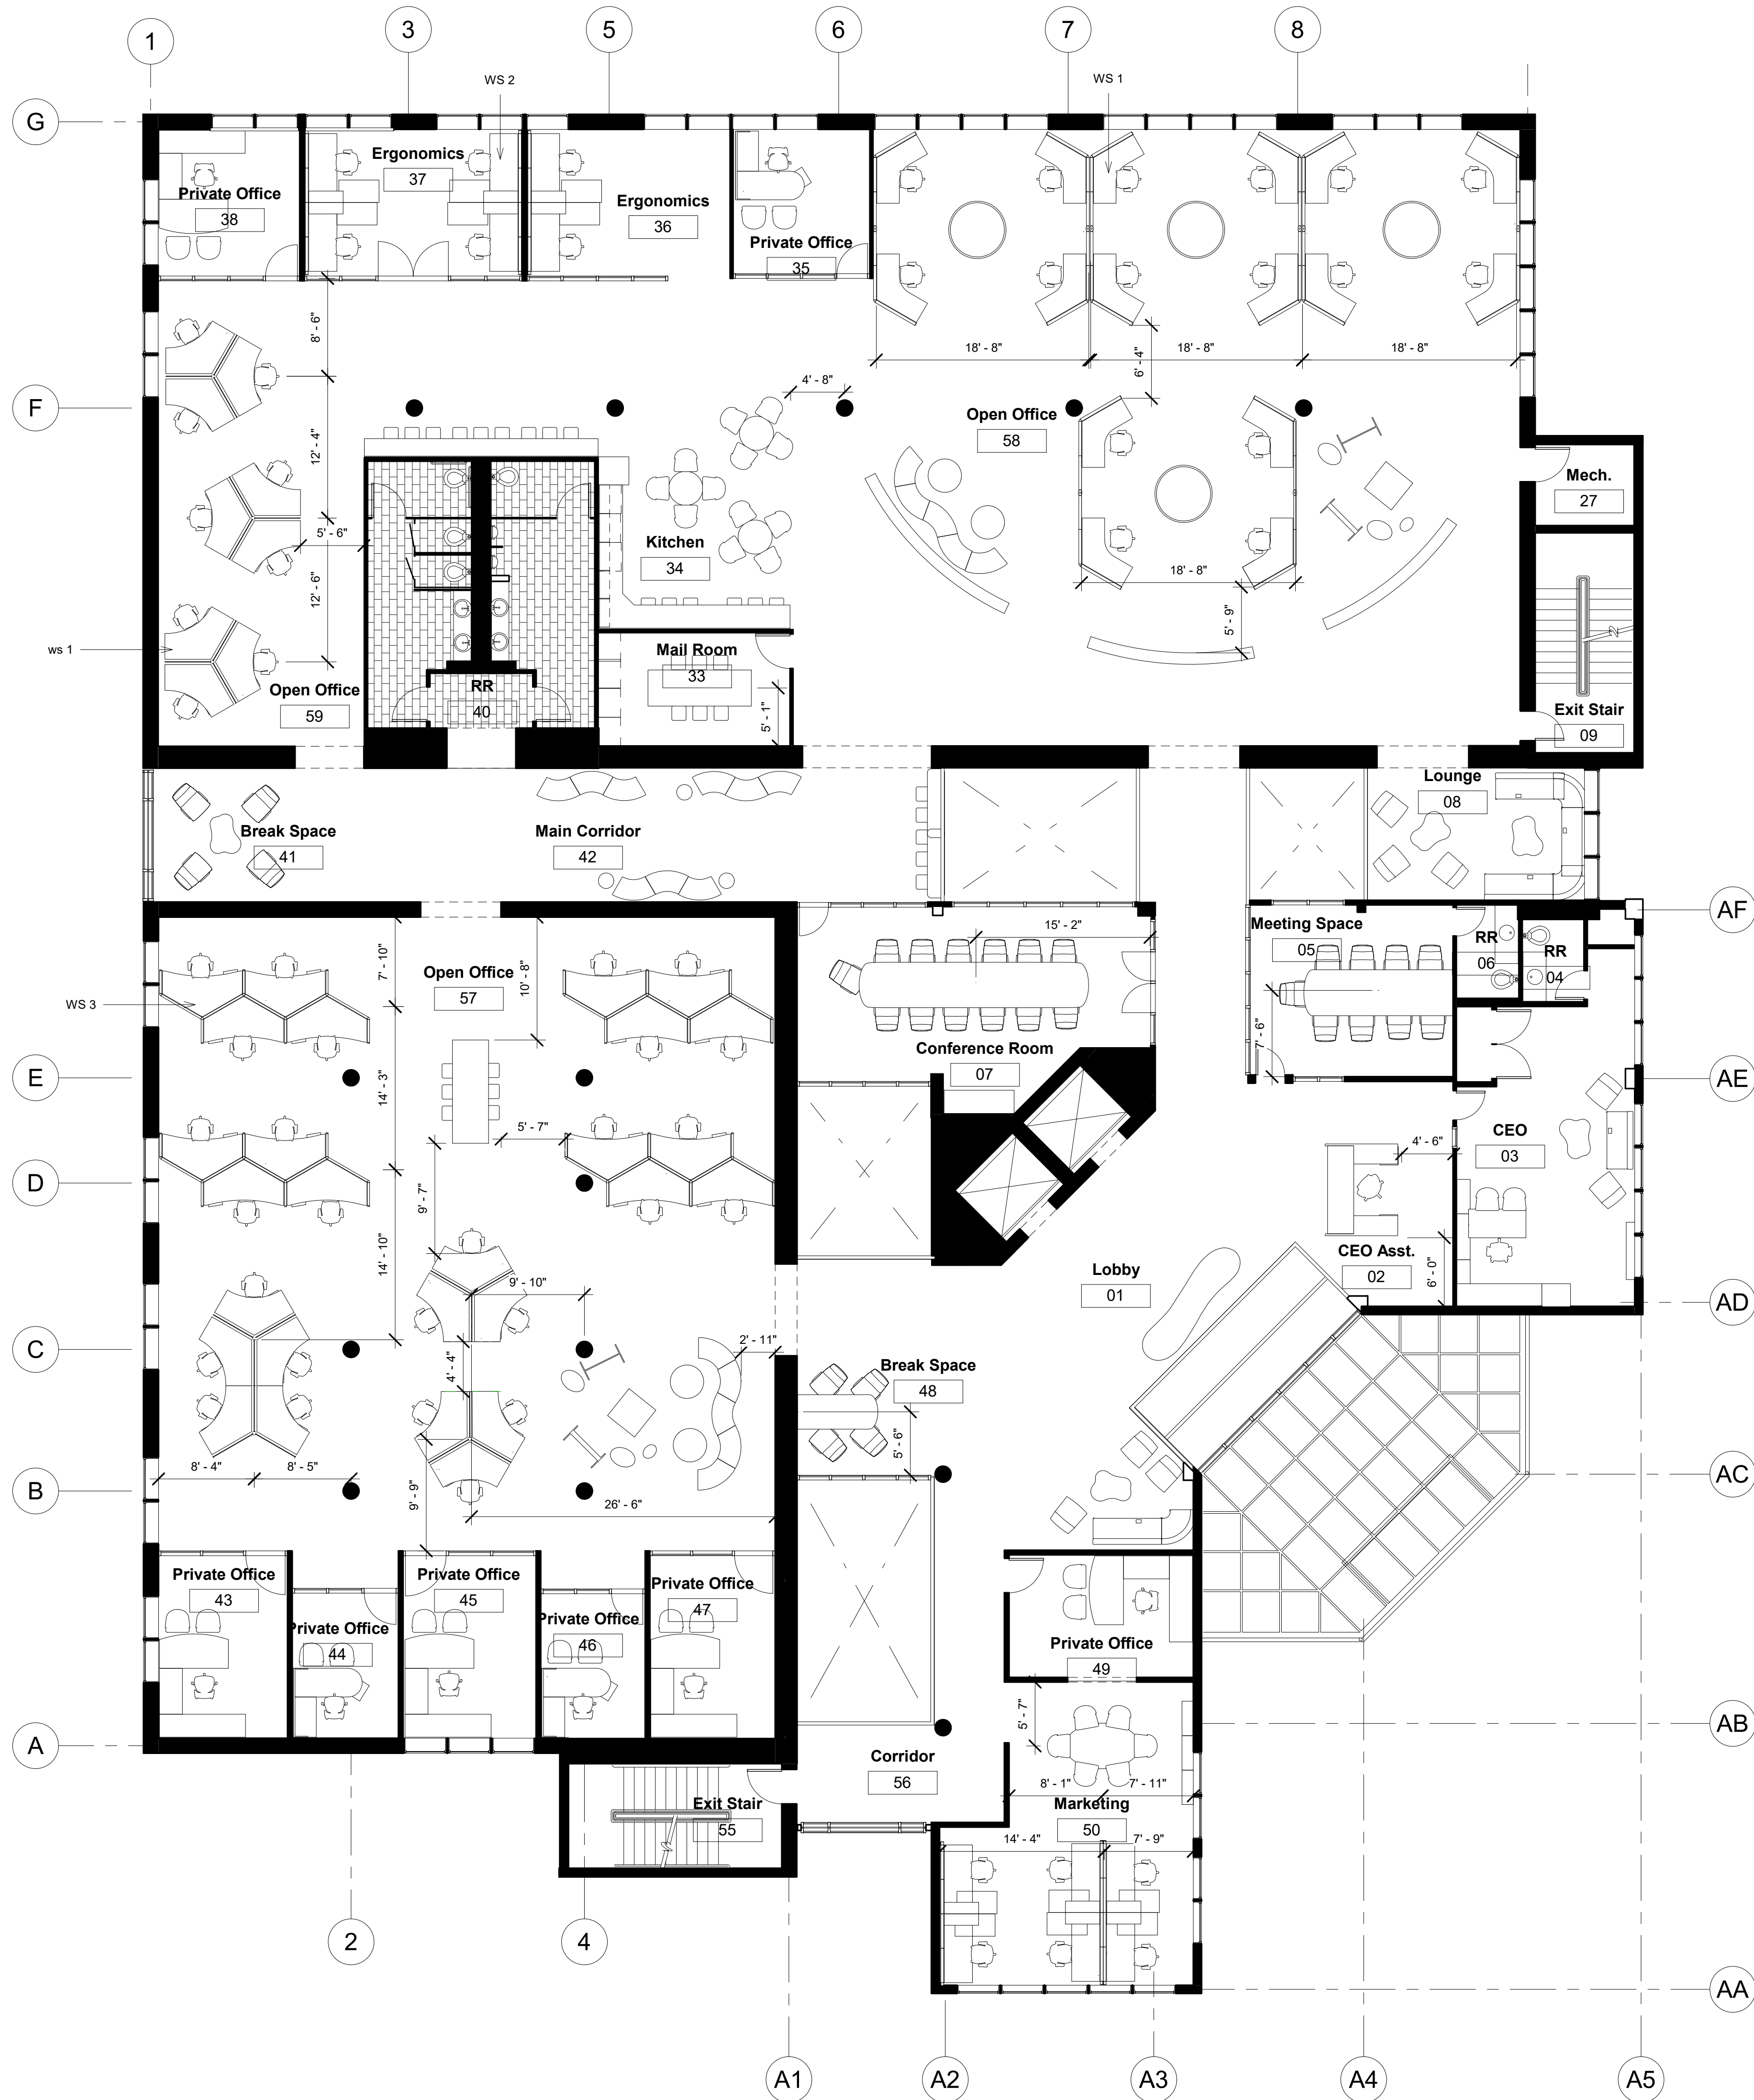


General Notes

- 1. This plan is for reference only
- 2. Knoll dealer is to provide a detailed plan

Workstation Legend

- WS 1 Antenna Workspaces
- WS 2 Dividends Horizon Workstation
- WS 3 Morrison Workstation

1 Furniture Plan
1/8" = 1'-0"

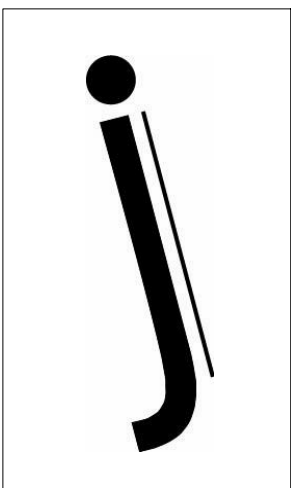

HUMANSCALE

Headquarters: Office Space
New York, New York

Client
Name:

Project
Name:

Project Number:
0123456789

Date Issued:
August 28, 2017


Sheet Content:

Furniture Plan
Workstation Legend

Drawn by: J.I.
Checked by: N.K.

Sheet Name:

Furniture Plan

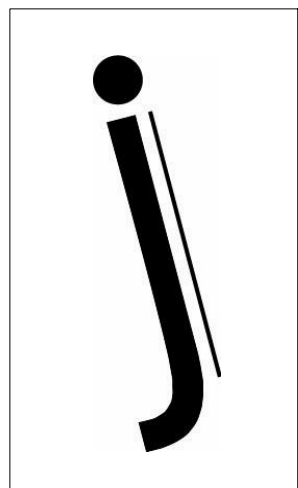

HUMANSCALE

Headquarters: Office Space
New York, New York

Client
Name:

Project
Name:

Project Number:
0123456789

Date Issued:
August 28, 2017

Sheet Content:

Finish Plan
Finish Legend
General Notes
Keynotes

Drawn by: J.I.

Checked by: N.K.

Sheet Name:

Finish Plan

A1. 05

General Notes:

1. Typical finish for all Private Offices
2. Typical finish for all Open Offices
3. Typical finish for all columns (WC-3)

Keynotes:

- 1 See sheet A3.01 for more information
- 2 See sheet A3.01 for more information
- 3 See sheet A3.01 for more information
- 4 See elevation on A3.02 for more information

Finish Legend:

Floors

Carpet

CPT-1 Manufacturer: Mohawk
Style: Digital Terrain
Number: GT341
Color: Lagoon
Size: 12" x 36"
Pattern: Half-lap

CPT-2 Manufacturer: Mohawk
Style: Digital Terrain
Number: GT341
Color: Sulphur
Size: 12" x 36"
Pattern: Half-lap

CPT-3 Manufacturer: Mohawk
Style: Digital Terrain
Number: GT341
Color: Coastal
Size: 12" x 36"
Pattern: Half-lap

CPT-4 Manufacturer: Mohawk
Style: Digital Terrain
Number: GT341
Color: Sediment
Size: 12" x 36"
Pattern: Half-lap

Tile

T-1 Manufacturer: Builddirect
Style: Salerno Raw Silk
Number: 10100097
Color: Black
Size: 12" x 24"
Pattern: Brick Ashlar

Base

Vinyl

BA-1 Manufacturer: Mercer
Style: Mirror-Finish
Color: Copper Metallic
Height: 4"
Thickness: .090"

Walls

Paint

P-1 Manufacturer: Sherwin Williams
Number: SW 6217
Color: Topsail

P-2 Manufacturer: Sherwin Williams
Number: SW 6112
Color: Biscuit

Wall Coverings

WC-1 Manufacturer: Kinon Surface Design
Style: 402
Size: 5'x12'


WC-2 Manufacturer: Eykon
Style: Splendor
Number: 2VSL-10
Color: Someday


WC-3 Manufacturer: Laminart
Style: 623- Brushed Steel
Color: Classic

Tile

WT-1 Manufacturer: Pantheon
Style: Zen Series
Number: 20-1201
Size: 18"x36"

WT-2 Manufacturer: Interlam
Style: SOT 002x2
Color: Copper Metallic
Size: 48" x 96"

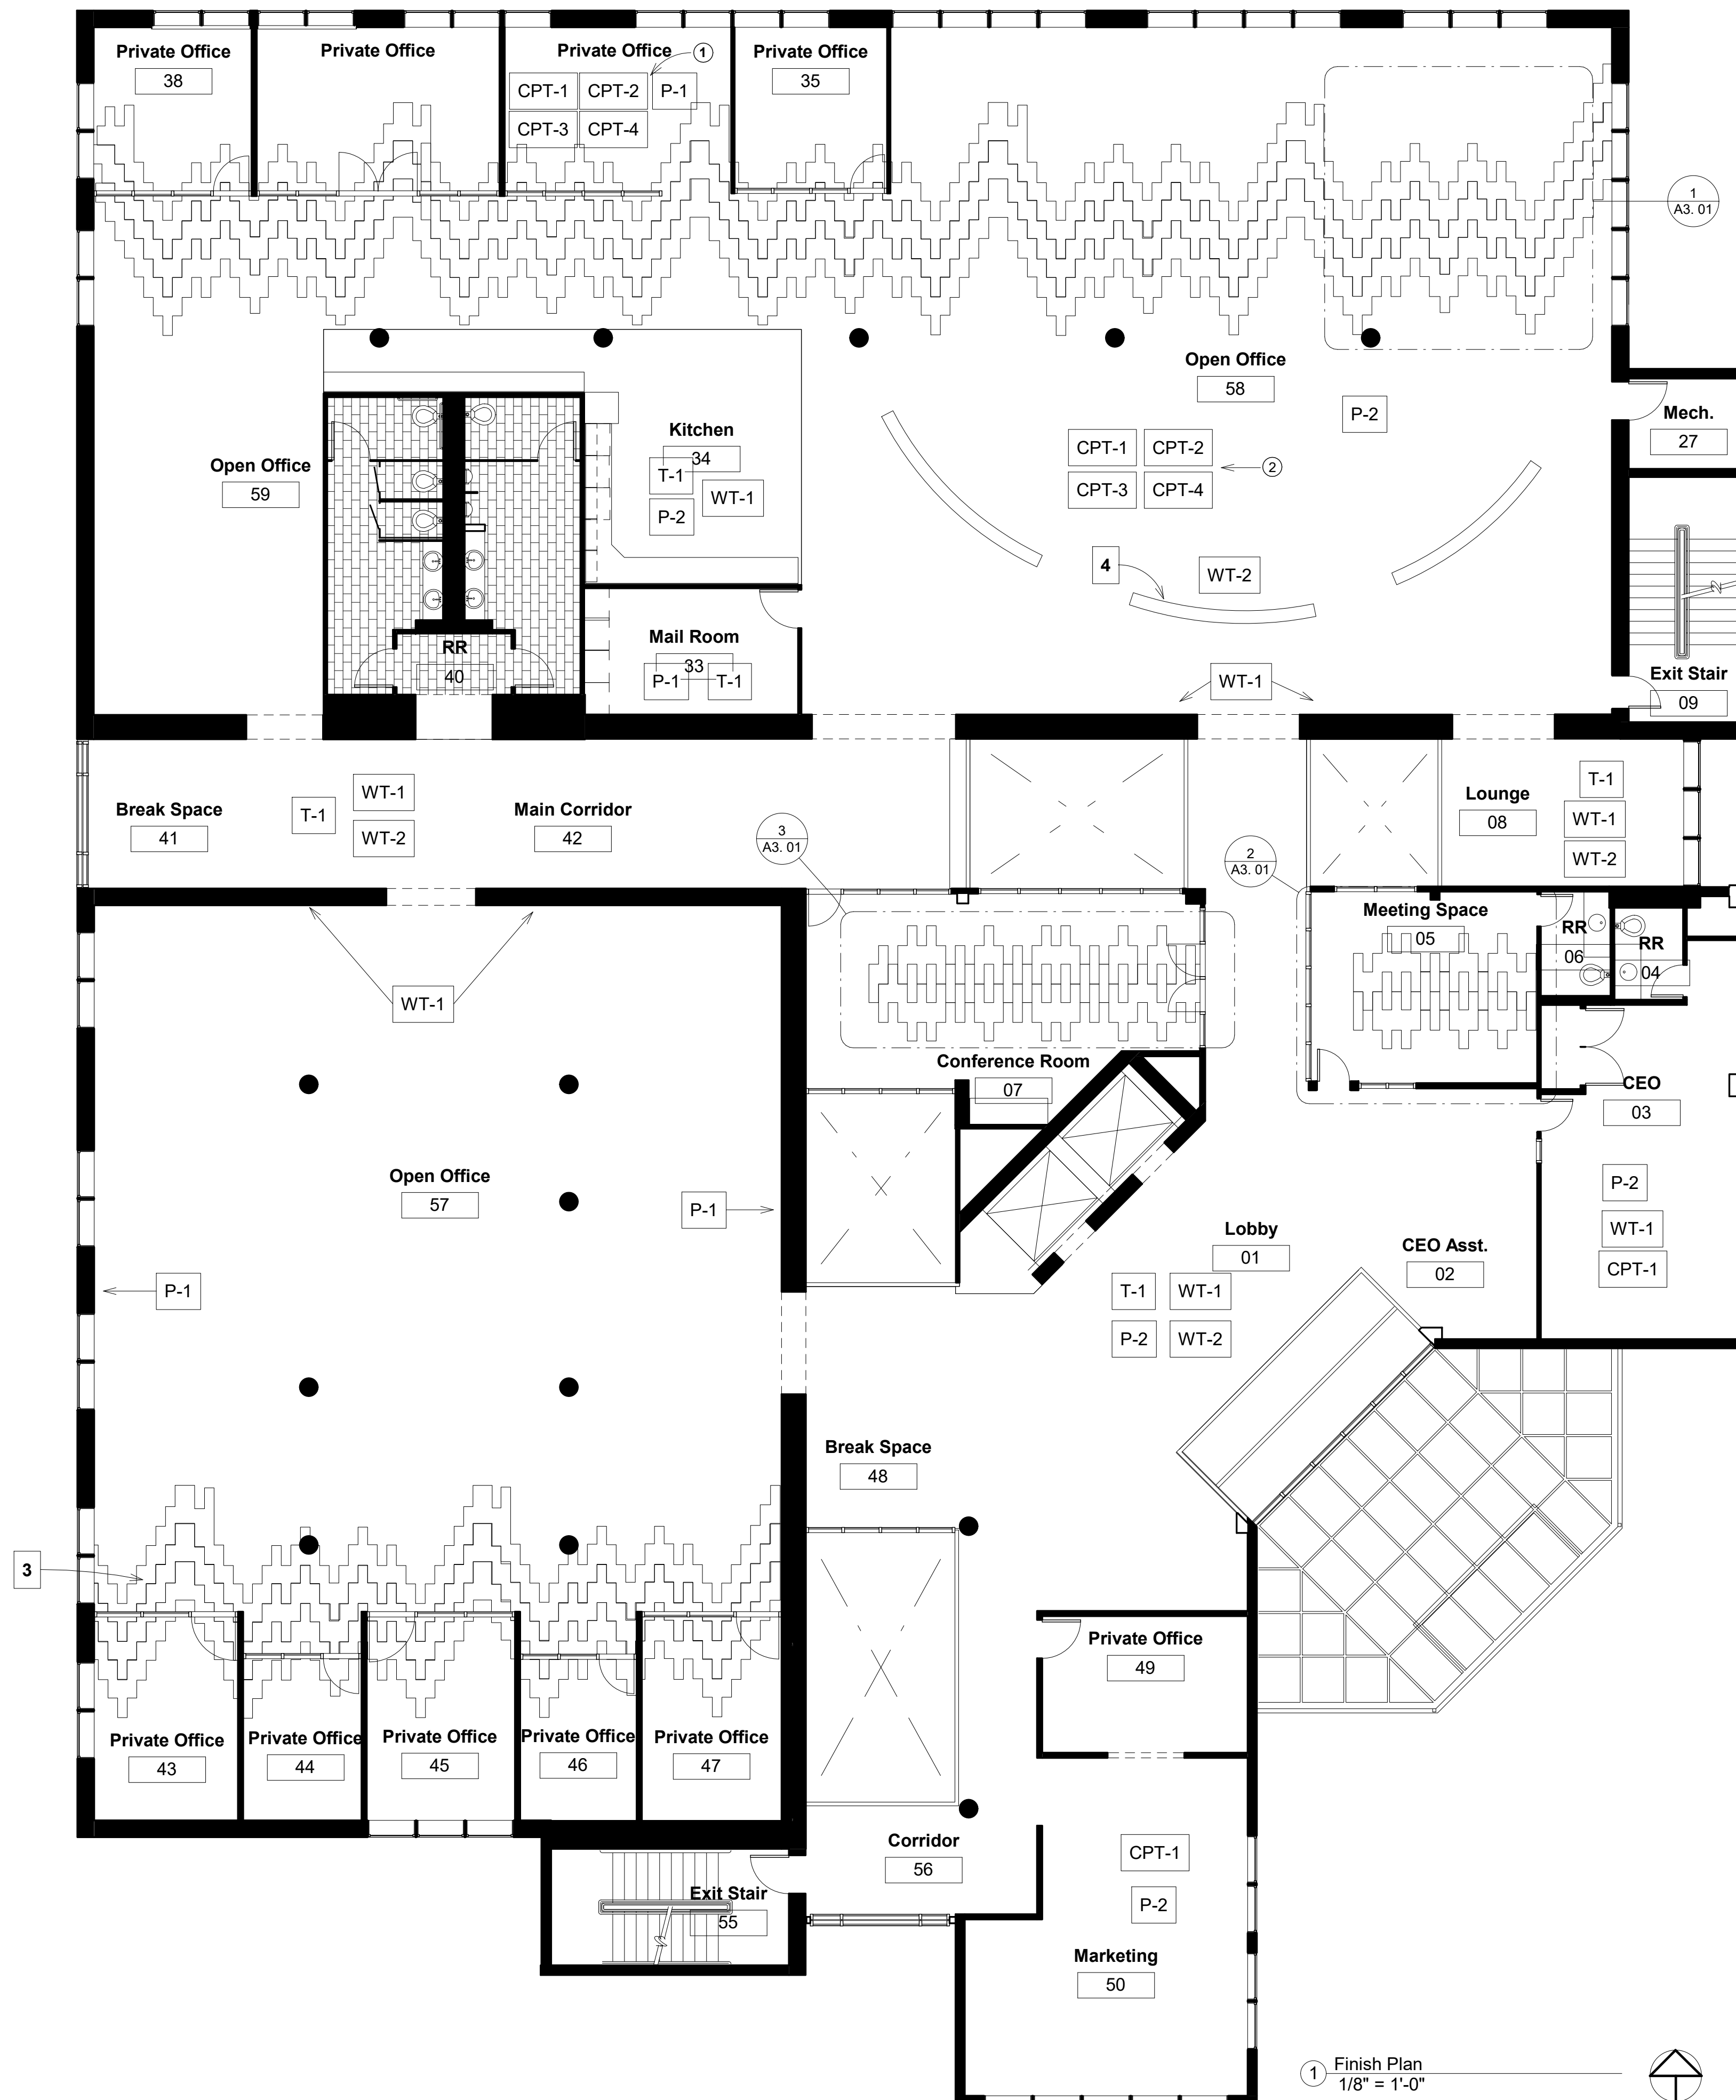

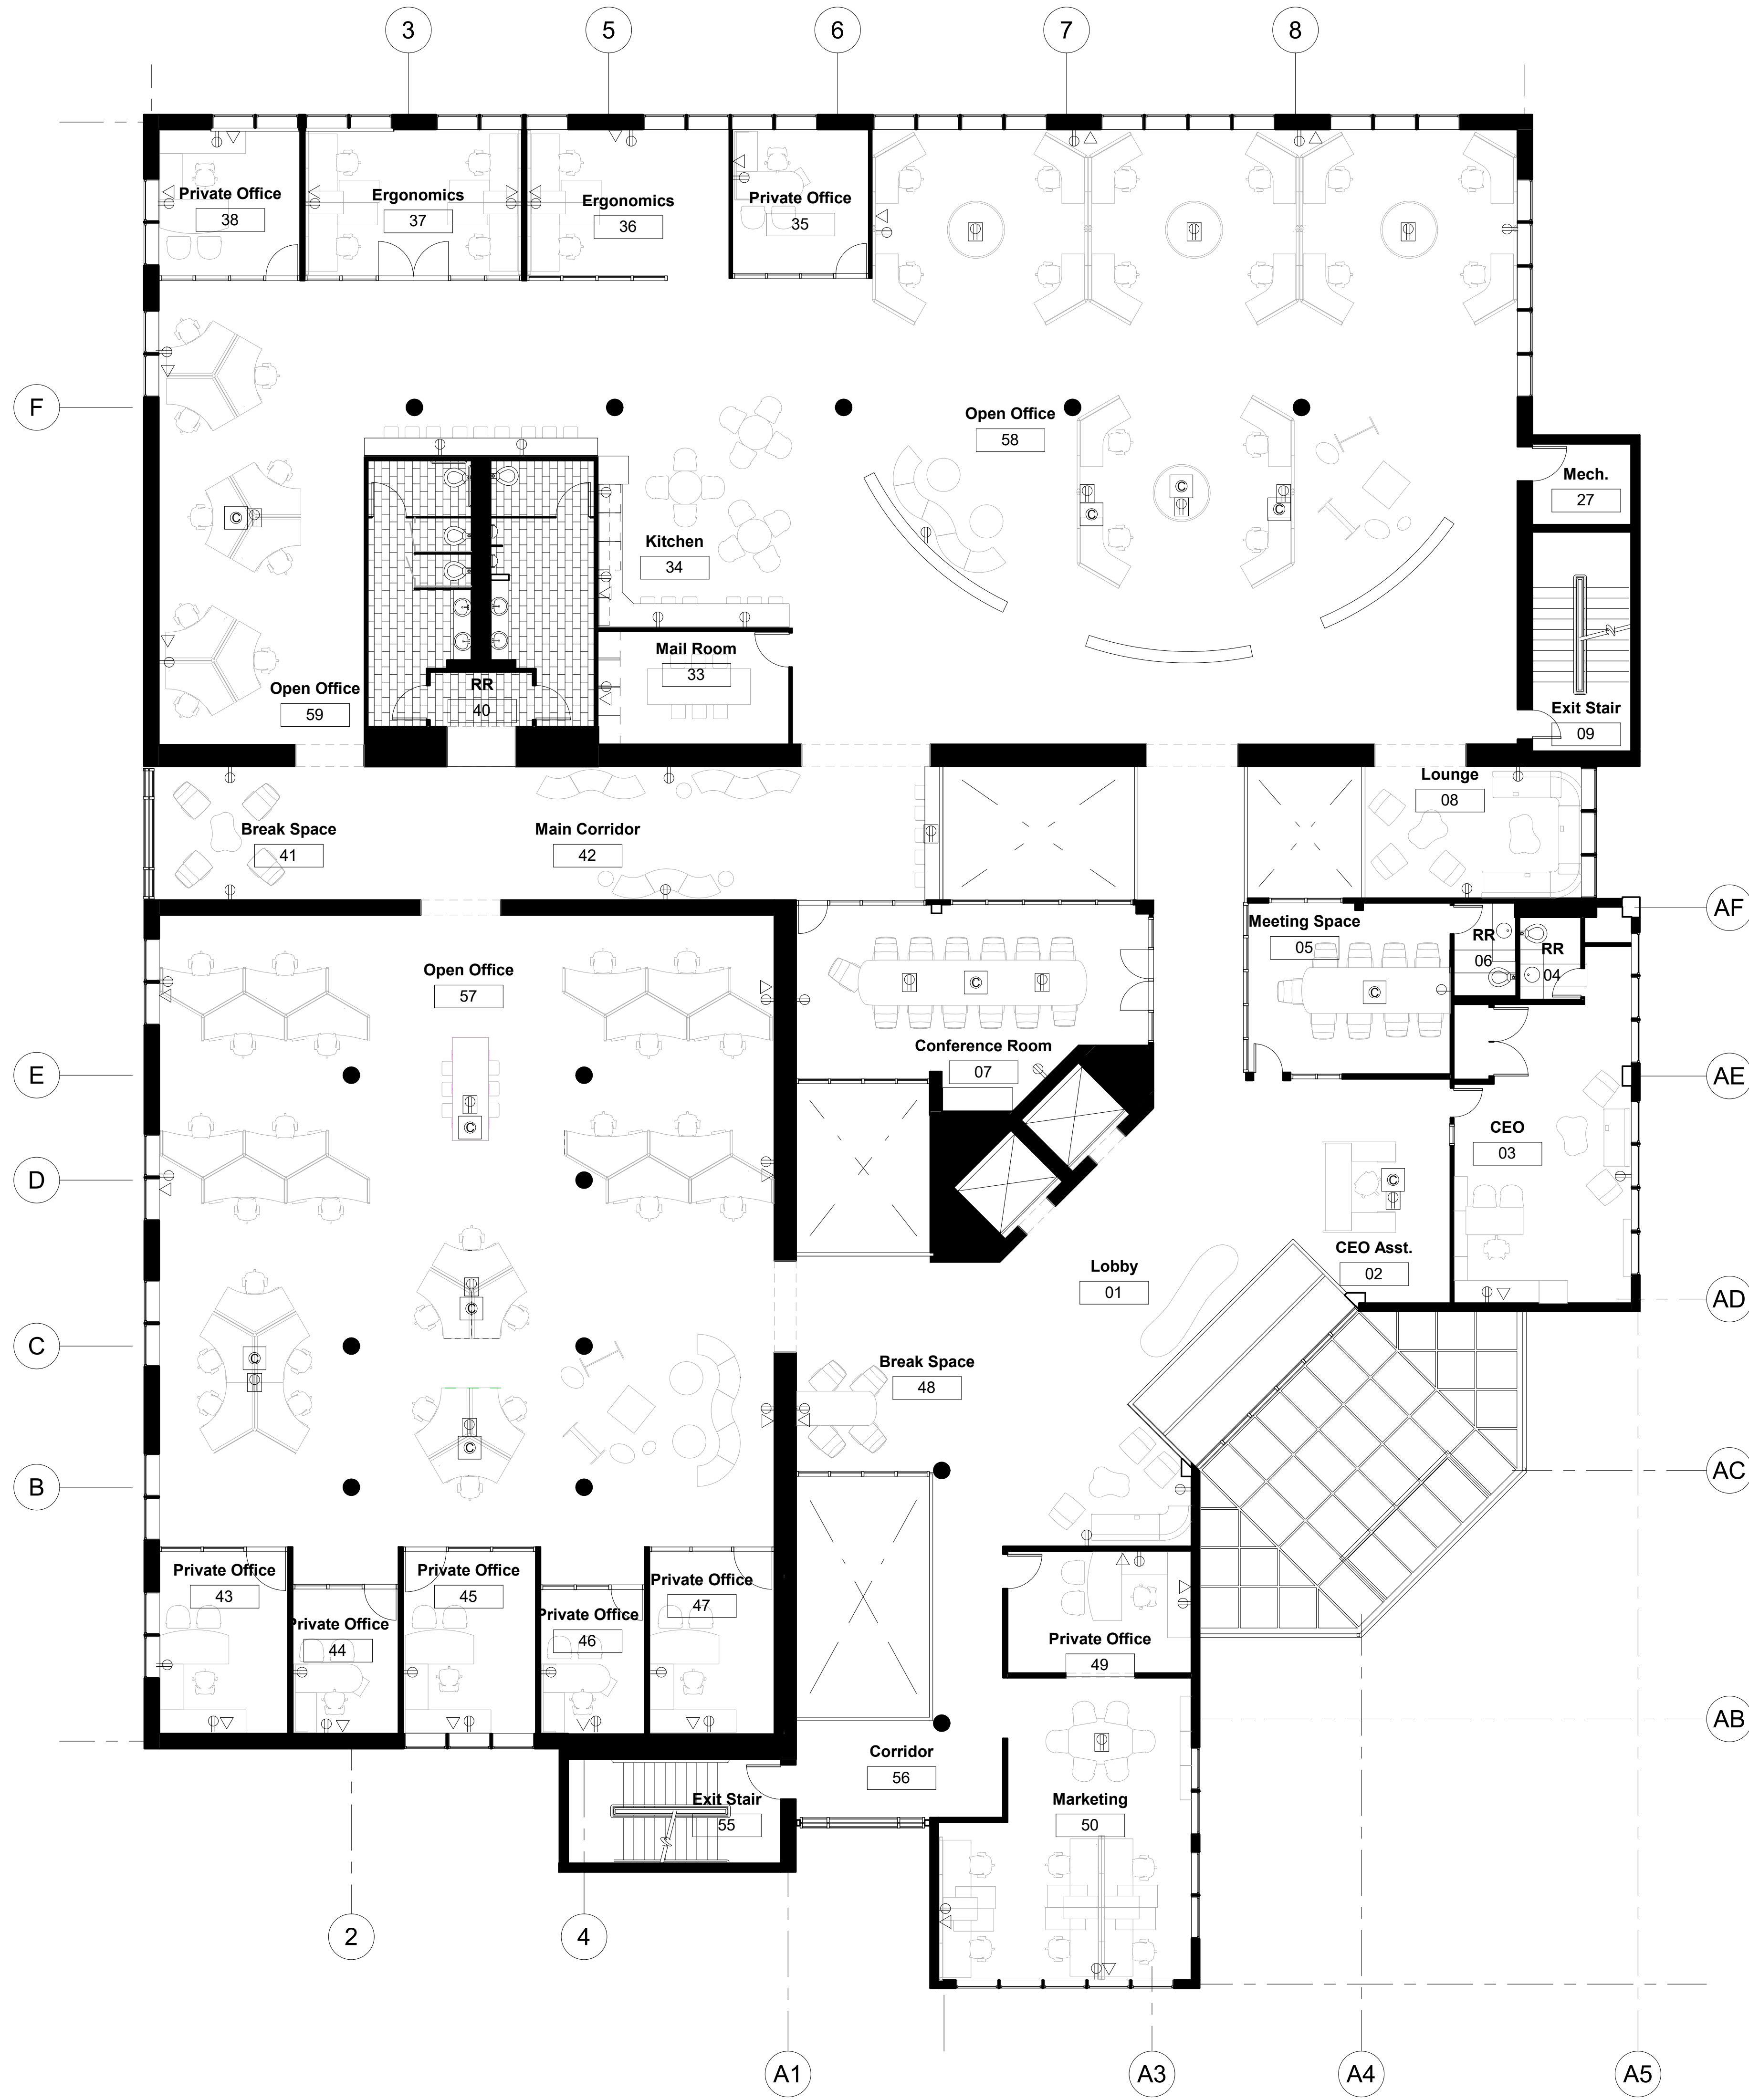


GENERAL NOTES

1. All electrical outlets to be grounded.
2. Power and communications layout to show outlet locations only. Designer is not responsible for electrical engineering.
3. All outlets to be located at center 10" A.F.F. U.N.O.
4. All cabinetry/casework outlets height to be above backsplash. See elevations.

Legend

-  Floor Data Outlet
-  Floor Duplex
-  Data
-  Duplex

1 Power and Data Plan
1/8" = 1'-0"

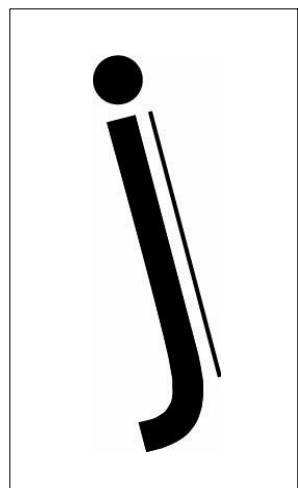

HUMANSCALE

Headquarters: Office Space
New York, New York

Client
Name:

Project
Name:

Project Number:
0123456789

Date Issued:
August 28, 2017


Sheet Content:

Power and Data Plan
Legend
General Notes

Drawn by: J.I.
Checked by: N.K.

Sheet Name:

Power and Data Plan

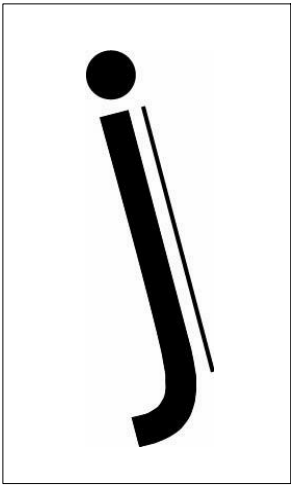

HUMANSCALE

Headquarters: Office Space
New York, New York

Client
Name:

Project
Name:

Project Number:
0123456789

Date Issued:
August 28, 2017

Sheet Content:

Arktura Ceiling Detail
Flooring Detail




Drawn by: J.I.
Checked by: N.K.

Sheet Name:


Interior Details

Arktura Ceiling Detail


- 82% open in plan
- Open percentage allows for the installation of sprinklers from above or between fins (reference your local building codes)
- Cameras, sensors, sprinklers, and lighting can be concealed between fins

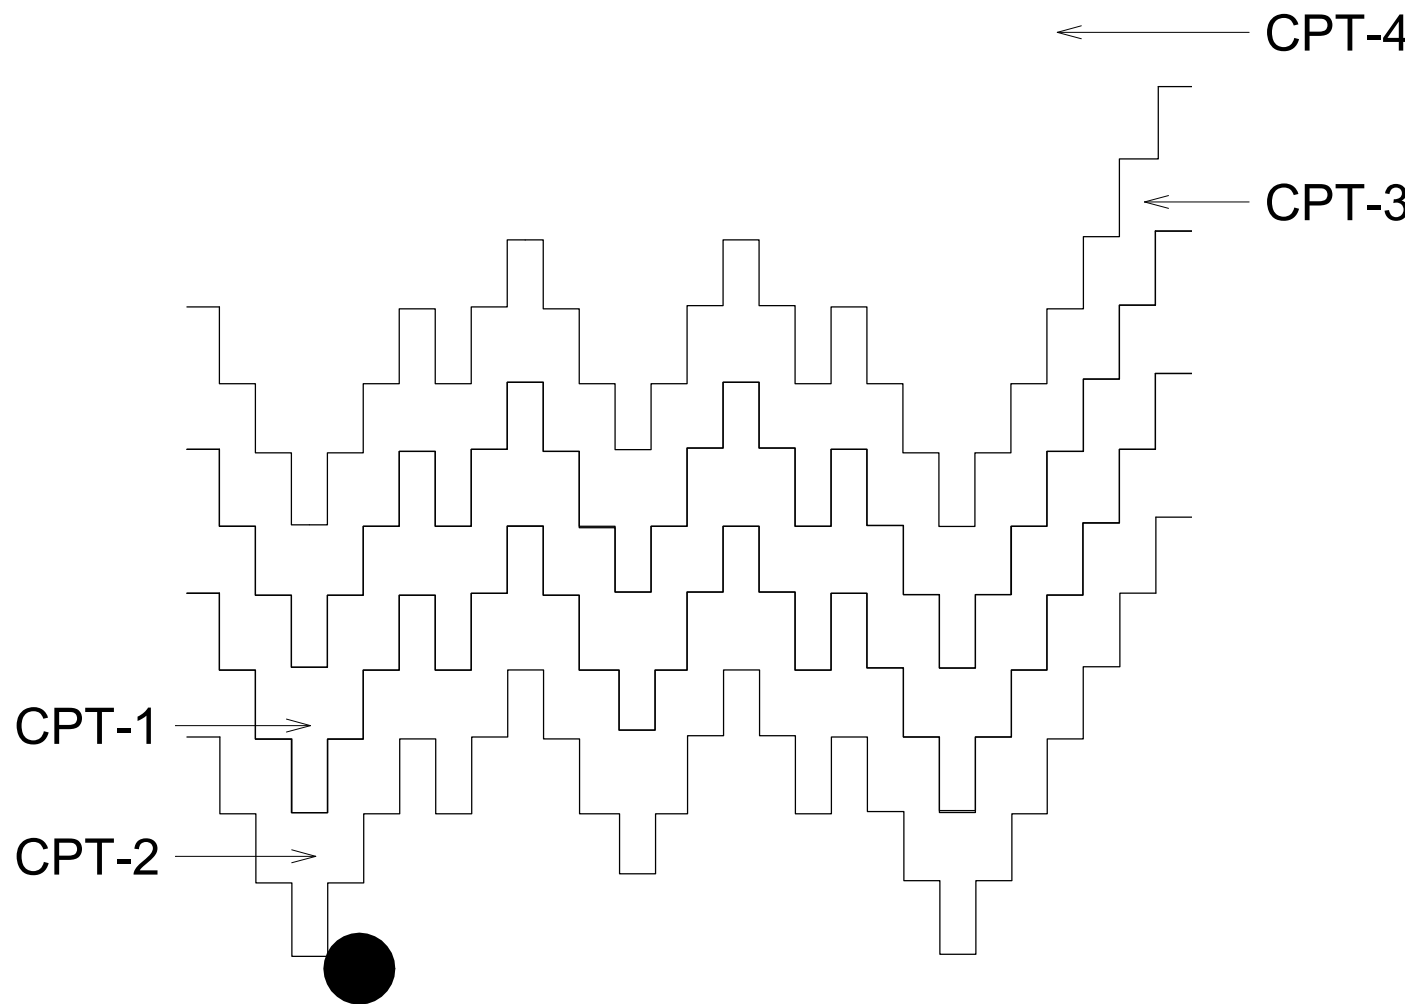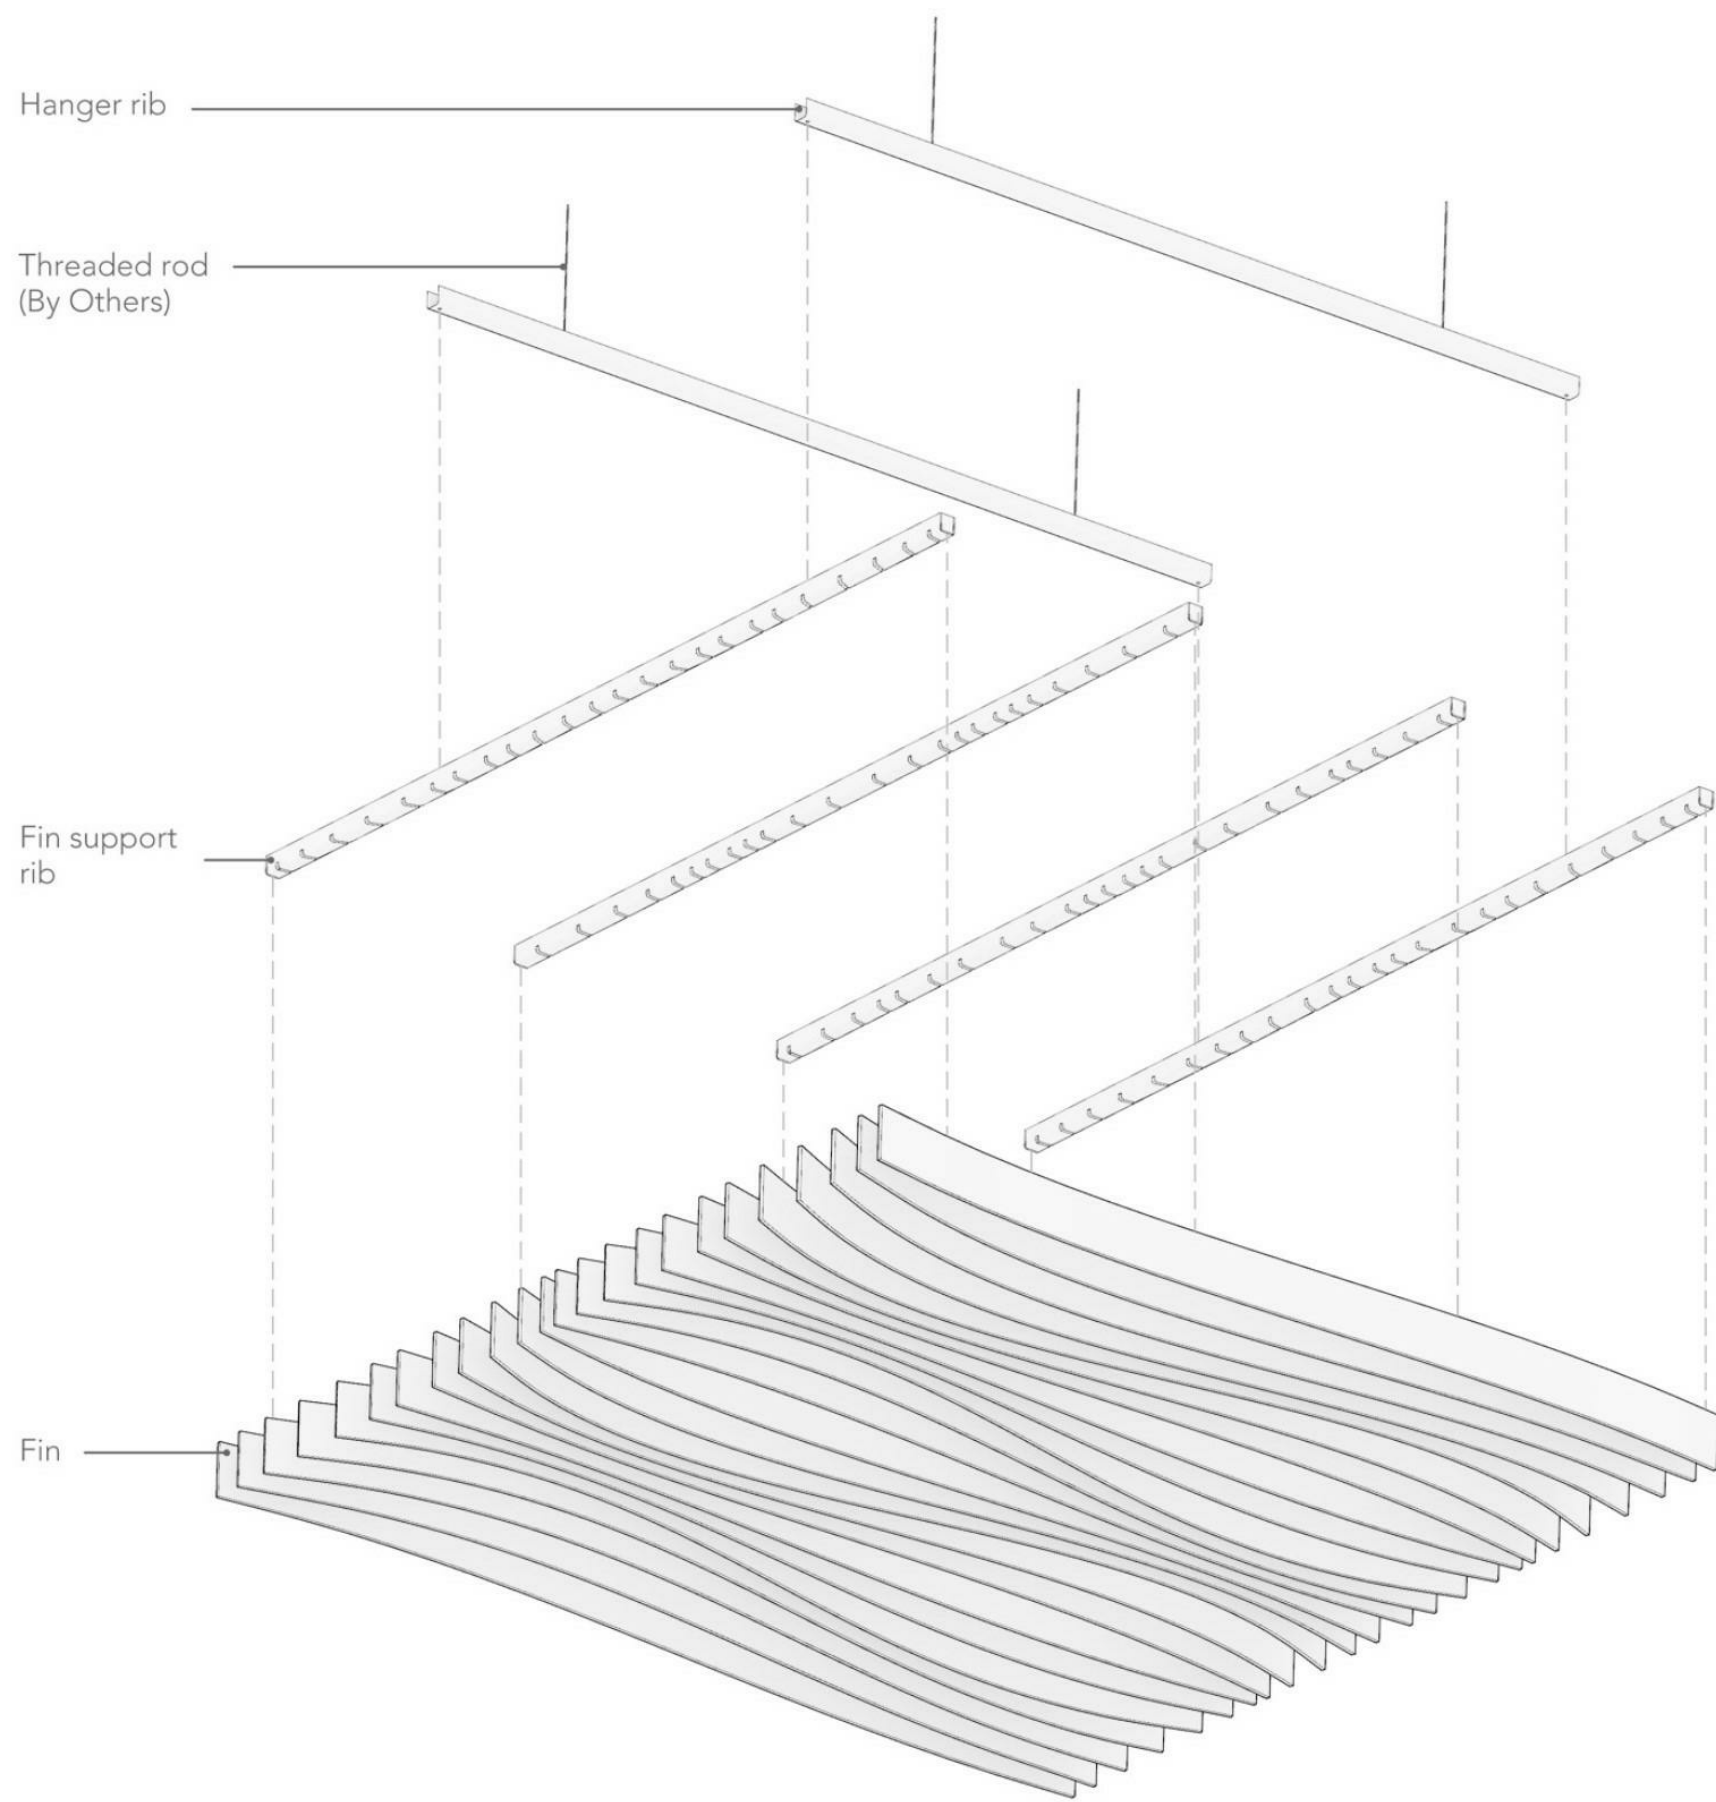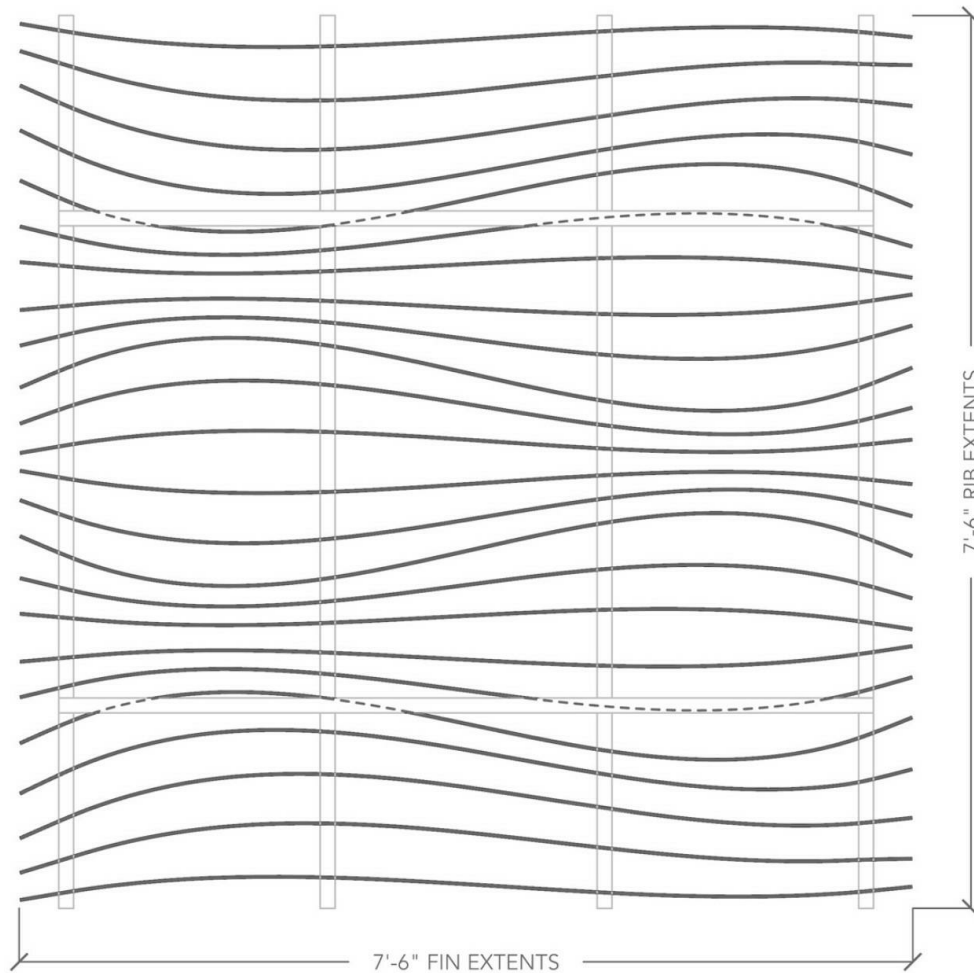

① Open Office Carpet Pattern
1/4" = 1'-0"

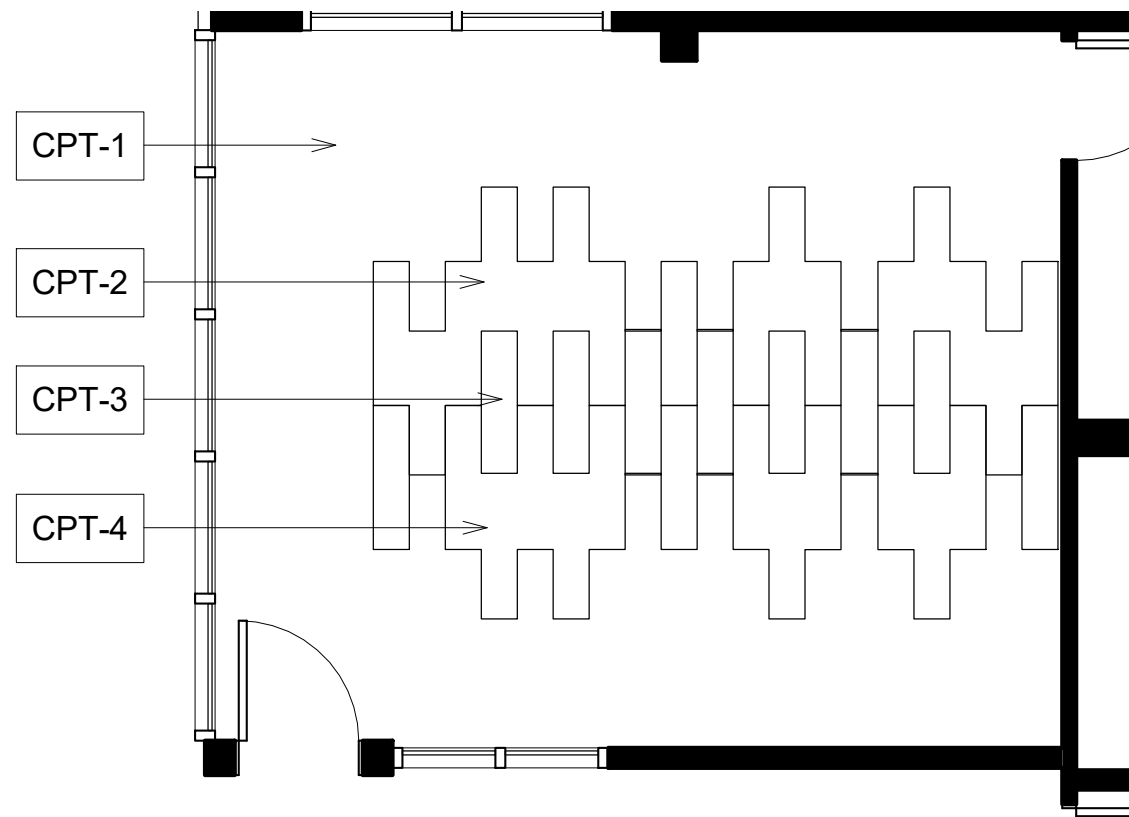

② Meeting Space Carpet Pattern
1/4" = 1'-0"

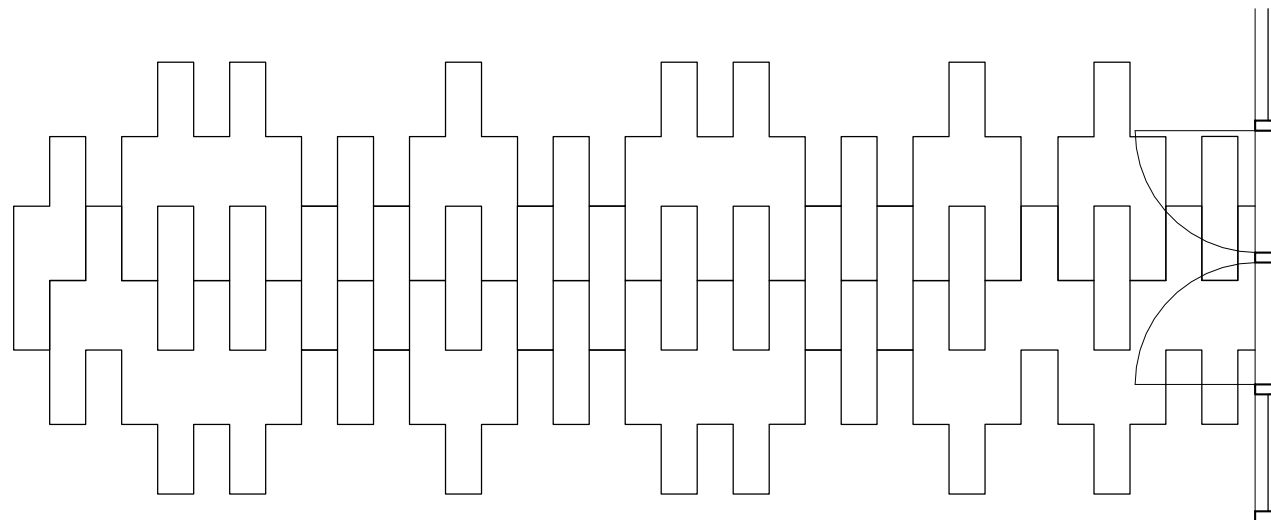

③ Conference Room Carpet Pattern
1/4" = 1'-0"

Walls

P-1

P-2

WC-1

WC-2

WC-3

WT-1

WT-2

T-1


LUM-1

PL-1

Vinyl

BA-1

Laminate

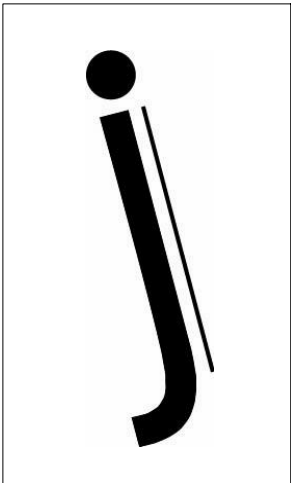

HUMANSCALE

Headquarters: Office Space
New York, New York

Client
Name:

Project
Name:

Project Number:
0123456789

Date Issued:
August 28,2017

Sheet Content:

Door Schedule
Finish Schedule




Drawn by: J.I.
Checked by: N.K.

Sheet Name:

Door Schedule

Door Schedule						
Mark	Type	Width	Height	Thickness	Frame Material	Finish
1	30" x 80"	2' - 6"	6' - 8"	0' - 2"	Mahogany	Mahogany
2	36" x 80"	3' - 0"	6' - 8"	0' - 2"	Mahogany	Mahogany
2	36" x 80"	3' - 0"	6' - 8"	0' - 2"	Mahogany	Mahogany
3	30" x 80"	2' - 6"	6' - 8"	0' - 2"	Mahogany	Mahogany
4	30" x 80"	2' - 6"	6' - 8"	0' - 2"	Mahogany	Mahogany
5	30" x 80"	2' - 6"	6' - 8"	0' - 2"	Mahogany	Mahogany
6	Door-Curtain-Wall-Single-Glass	2' - 6 1/2"	7' - 8 1/4"	0' - 2"	Steel	Glass
7	Door-Curtain-Wall-Single-Glass	2' - 6 1/2"	7' - 8 1/4"	0' - 2"	Steel	Glass
8	Door-Curtain-Wall-Single-Glass	2' - 6 3/8"	7' - 8 1/4"	0' - 2"	Steel	Glass
9	30" x 80"	2' - 6"	6' - 8"	0' - 2"	Mahogany	Mahogany
10	36" x 80"	3' - 0"	6' - 8"	0' - 2"	Mahogany	Mahogany
11	36" x 80"	3' - 0"	6' - 8"	0' - 2"	Mahogany	Mahogany
12	Door-Curtain-Wall-Single-Glass	2' - 8 1/32"	7' - 8 1/4"	0' - 2"	Steel	Glass
13	Door-Curtain-Wall-Single-Glass	3' - 0 11/16"	7' - 8 1/4"	0' - 2"	Steel	Glass
14	Door-Curtain-Wall-Single-Glass	3' - 0 11/16"	7' - 8 1/4"	0' - 2"	Steel	Glass
15	Door-Curtain-Wall-Single-Glass	2' - 9 9/32"	7' - 8 1/4"	0' - 2"	Steel	Glass
16	36" x 80"	3' - 0"	6' - 8"	0' - 2"	Mahogany	Mahogany
16.F	36" x 80"	3' - 0"	6' - 8"	0' - 2"	Mahogany	Mahogany
16.M	36" x 80"	3' - 0"	6' - 8"	0' - 2"	Mahogany	Mahogany
17	Door-Curtain-Wall-Single-Glass	3' - 5 7/32"	7' - 8 1/4"	0' - 2"	Steel	Glass
18	Door-Curtain-Wall-Single-Glass	2' - 9 1/4"	7' - 8 1/4"	0' - 2"	Steel	Glass
18	36" x 80"	3' - 0"	6' - 8"	0' - 2"	Mahogany	Mahogany
19	Door-Curtain-Wall-Single-Glass	3' - 6 5/8"	7' - 8 1/4"	0' - 2"	Steel	Glass
20	Door-Curtain-Wall-Single-Glass	2' - 8 21/32"	7' - 8 1/4"	0' - 2"	Steel	Glass
21	Door-Curtain-Wall-Single-Glass	3' - 3 15/16"	7' - 8 1/4"	0' - 2"	Steel	Glass
22	36" x 80"	3' - 0"	6' - 8"	0' - 2"	Mahogany	Mahogany
23	36" x 80"	3' - 0"	6' - 8"	0' - 2"	Mahogany	Mahogany

Finish Schedule						
Number	Name	Floor Finish	Base Finish	Wall Finish (N, E, S, W)	Ceiling Finish	Comments
201	Lobby	T-1	BA-1	WT-1, WT-1, WT-2, WT-1	PNT-1,Aktura	See RCP (A1. 03)
202	CEO Assistant	T-1	BA-1	Glass, WT-2, WT-1, N/A	PNT-1,Aktura	See RCP (A1. 03)
203	CEO Office	CPT-1	BA-1	P-2, P-2, WT-1, P-2	ACT	
204	Restroom	Existing	Existing	Existing	Existing	
205	Meeting Space	CPT-1,CPT-2,CPT-3,CPT-4	BA-1	Glass, WT-1, Glass, Glass	PNT-1	See Interior Detail (A3.01)
206	Restroom	Existing	Existing	Existing	Existing	
207	Conference Room	CPT-1,CPT-2,CPT-3,CPT-4	BA-1	Glass, Glass, P-2, WT-1	PNT-1	See Interior Detail (A3.01)
208	Lounge	T-1	BA-1	WT-1, Glass, WT-2, Glass	PNT-1,Aktura	See RCP (A1. 03)
209	Exit Stair	Existing	Existing	Existing	Existing	
210	Mechanical	Existing	Existing	Existing	Existing	
211	Open Office	CPT-1,CPT-2,CPT-3,CPT-4	BA-1	P-2, P-2, WT-2, N/A	PNT-1, WC-1	See RCP (A1. 03) and Interior Detail (A3.01)
212	Mail Room	CPT-1	BA-1	P-2, P-2, P-2, P-2	ACT	See Interior Detail (A3.01)
213	Kitchen	T-1	BA-1	N/A, N/A, WT-1, P-2	PNT-1	
214	Private Office	CPT-1,CPT-2,CPT-3,CPT-4	BA-1	WC-2, P-2, Glass, P-2	ACT	See Interior Detail (A3.01)
215	Private Office	CPT-1,CPT-2,CPT-3,CPT-4	BA-1	WC-2, P-2, Glass, P-2	ACT	See Interior Detail (A3.01)
216	Private Office	CPT-1,CPT-2,CPT-3,CPT-4	BA-1	WC-2, P-2, Glass, P-2	ACT	See Interior Detail (A3.01)
217	Private Office	CPT-1,CPT-2,CPT-3,CPT-4	BA-1	WC-2, P-2, Glass, P-2	ACT	See Interior Detail (A3.01)
218	Open Office	CPT-1,CPT-2,CPT-3,CPT-4	BA-1	Glass, P-2, P-2, P-2	PNT-1, WC-1	See RCP (A1. 03)
219	Restroom	Existing	Existing	Existing	Existing	
220	Main Corridor	T-1	BA-1	WT-1, Glass, WT-2, Glass	PNT-1,Aktura	See RCP (A1. 03)
221	Open Office	CPT-1,CPT-2,CPT-3,CPT-4	BA-1	WT-1, P-2, Glass, P-2	PNT-1, WC-1	See RCP (A1. 03)
222	Private Office	CPT-1,CPT-2,CPT-3,CPT-4	BA-1	Glass, P-2, WC-2, P-2	ACT	See Interior Detail (A3.01)
223	Private Office	CPT-1,CPT-2,CPT-3,CPT-4	BA-1	Glass, P-2, WC-2, P-2	ACT	See Interior Detail (A3.01)
224	Private Office	CPT-1,CPT-2,CPT-3,CPT-4	BA-1	Glass, P-2, WC-2, P-2	ACT	See Interior Detail (A3.01)
225	Private Office	CPT-1,CPT-2,CPT-3,CPT-4	BA-1	Glass, P-2, WC-2, P-2	ACT	See Interior Detail (A3.01)
226	Private Office	CPT-1,CPT-2,CPT-3,CPT-4	BA-1	Glass, P-2, WC-2, P-2	ACT	See Interior Detail (A3.01)
227	Private Office	CPT-1	BA-1	Glass, P-2, WC-2, P-2	ACT	
228	Marketing	CPT-1	BA-1	P-2, P-2, P-2, WC-2	PNT-1	
229	Exit Stair	Existing	Existing	Existing	Existing	

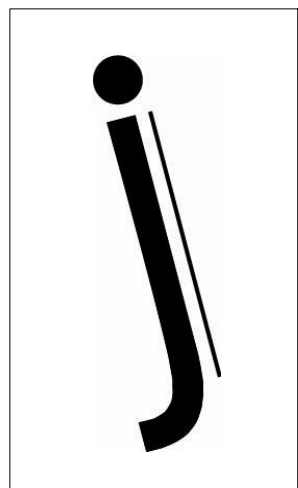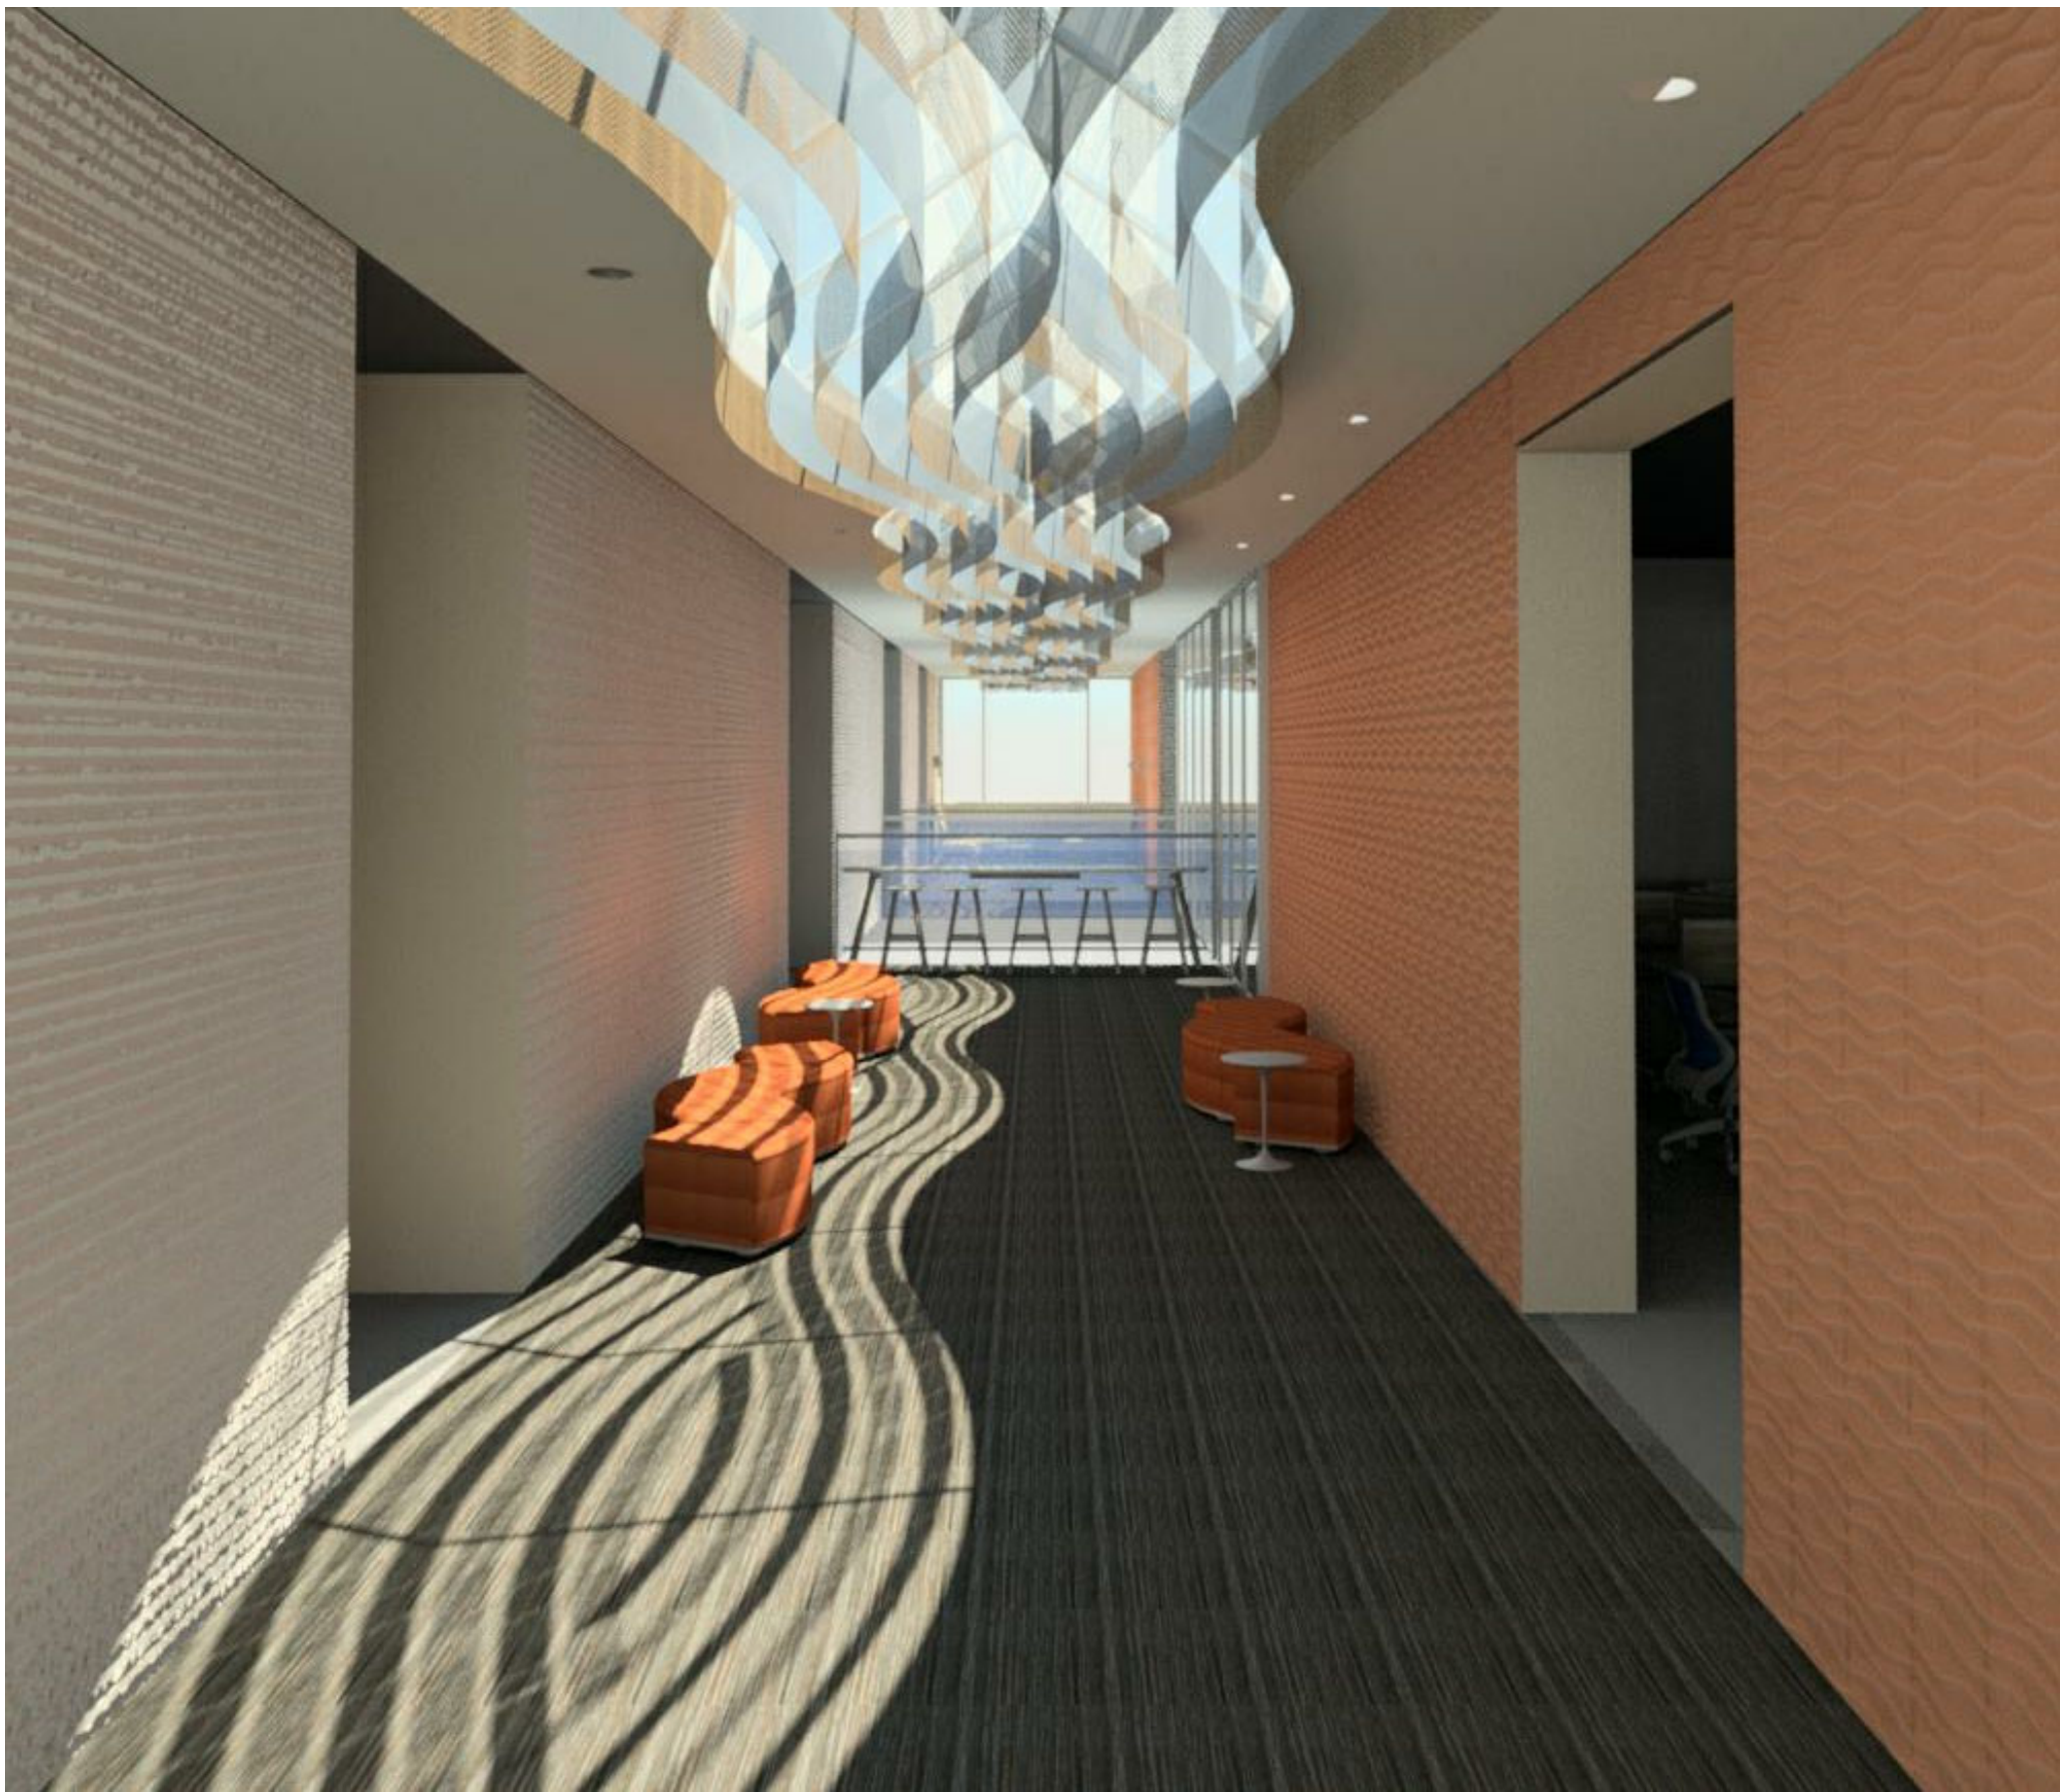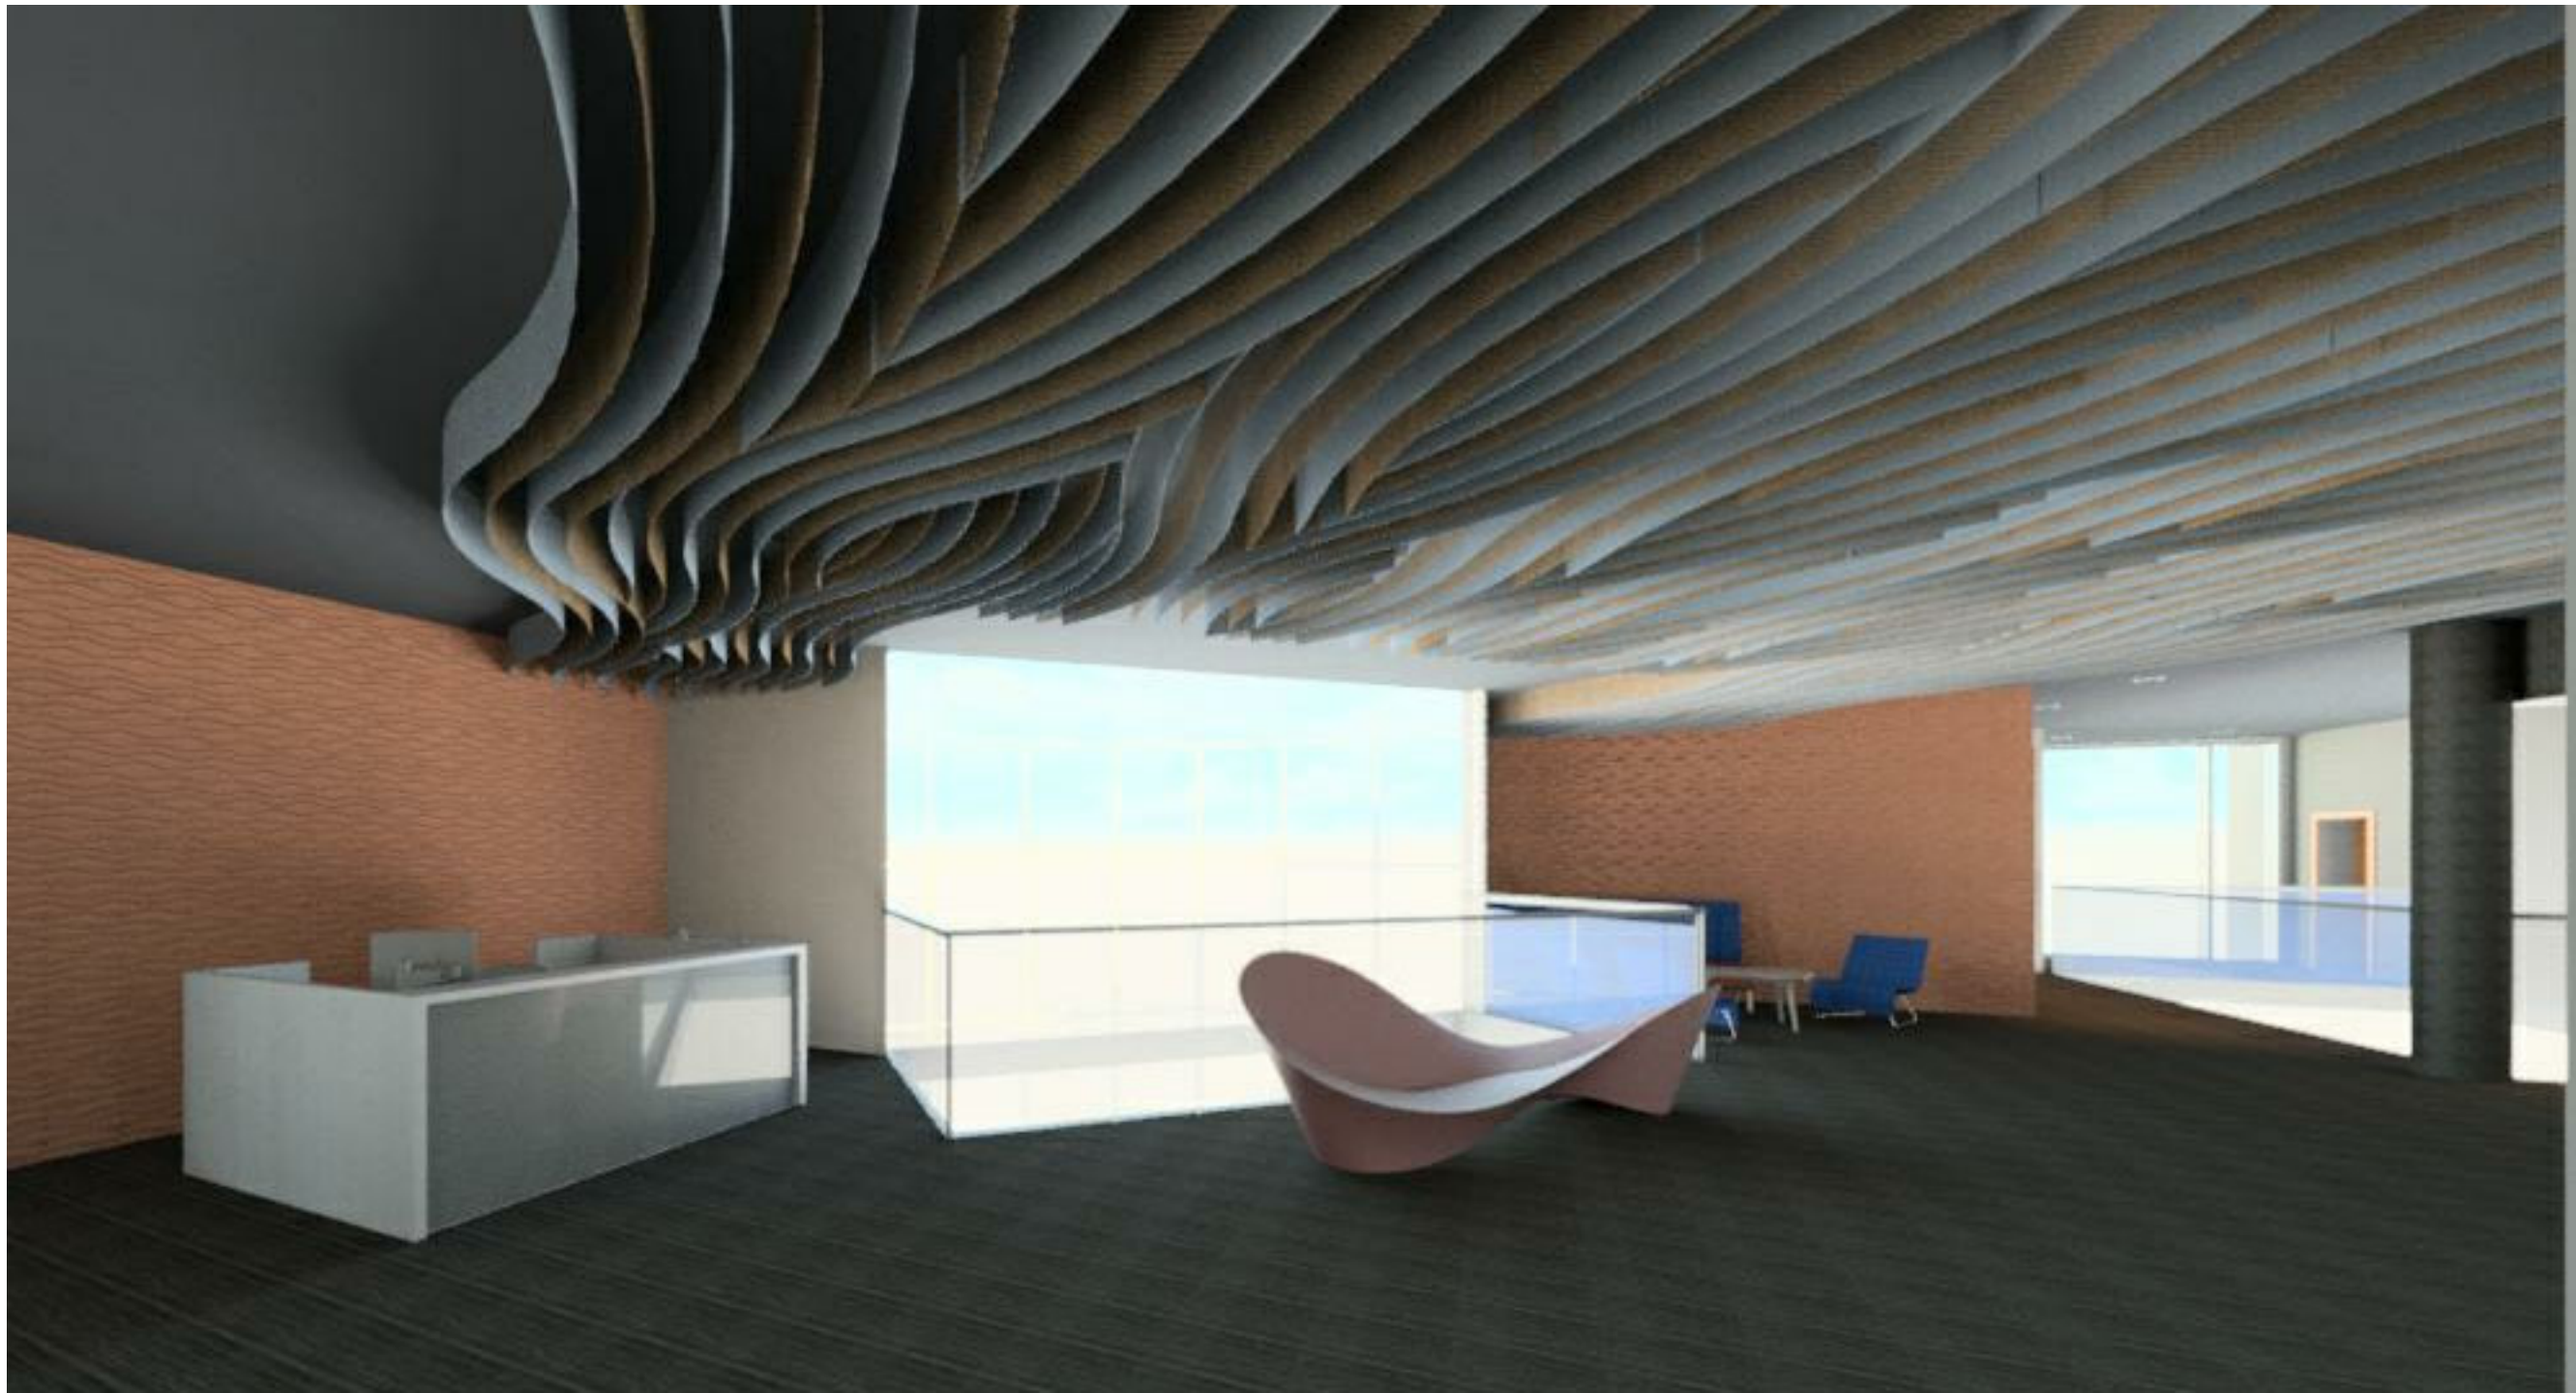

HUMANSCALE

Headquarters: Office Space
New York, New York

Client
Name:

Project
Name:

Project Number:
0123456789

Date Issued:
August 28, 2017

Sheet Content:

3D Views

Drawn by: J.I.
Checked by: N.K.

Sheet Name:

3D Views

A9. 01